


**BLOCK PLAN**  
SCALE 1:200

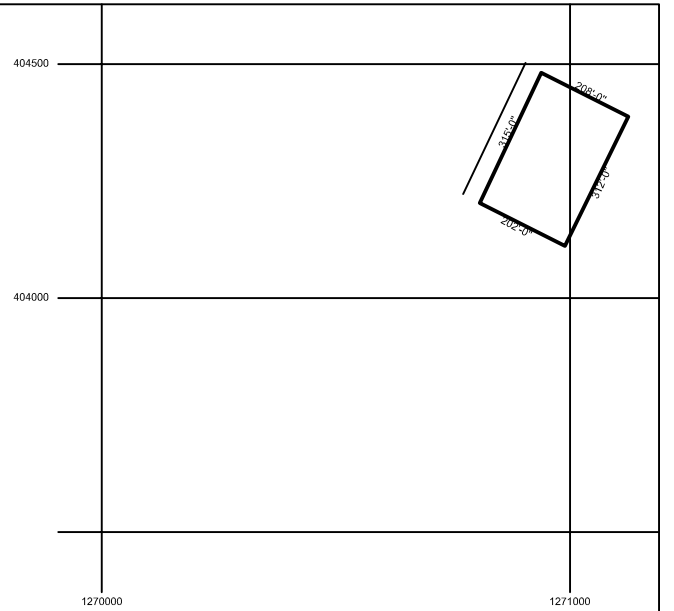

**SITE PLAN**  
SCALE 1:2500

**NOTES**

Do not scale dimensions from drawings. Contractors, Sub-Contractors and Suppliers must verify all dimensions before commencing any work or making any shop drawings.

Should any divergence in dimensions occur between architectural, engineering or Sub-Contractors drawings, the Contractor shall immediately contact the Architect for clarification.

NO.	DESCRIPTION	DESIGN	CHECK	APPROVED	DATE

CLIENT: ANSAH AGYEMANG BARIMAH AND RITA AGYEMANG BARIMAH

LOCATION: ADWEMADOR -GREATER ACCRA REGION

PROJECT: PROPOSED FIVE STOREY SCHOOL BLOCK

DRAWING TITLE: AS INDICATED

CHECKED BY: \_\_\_\_\_

DESIGNED BY: NICHOLAS

DRAWN BY: NICHOLAS


DATE: NOV.2021

SCALE: 1:100 & 1:25

SHEET No.: 012

Drg. no. **AR.01**

SHE. SIZE -A3

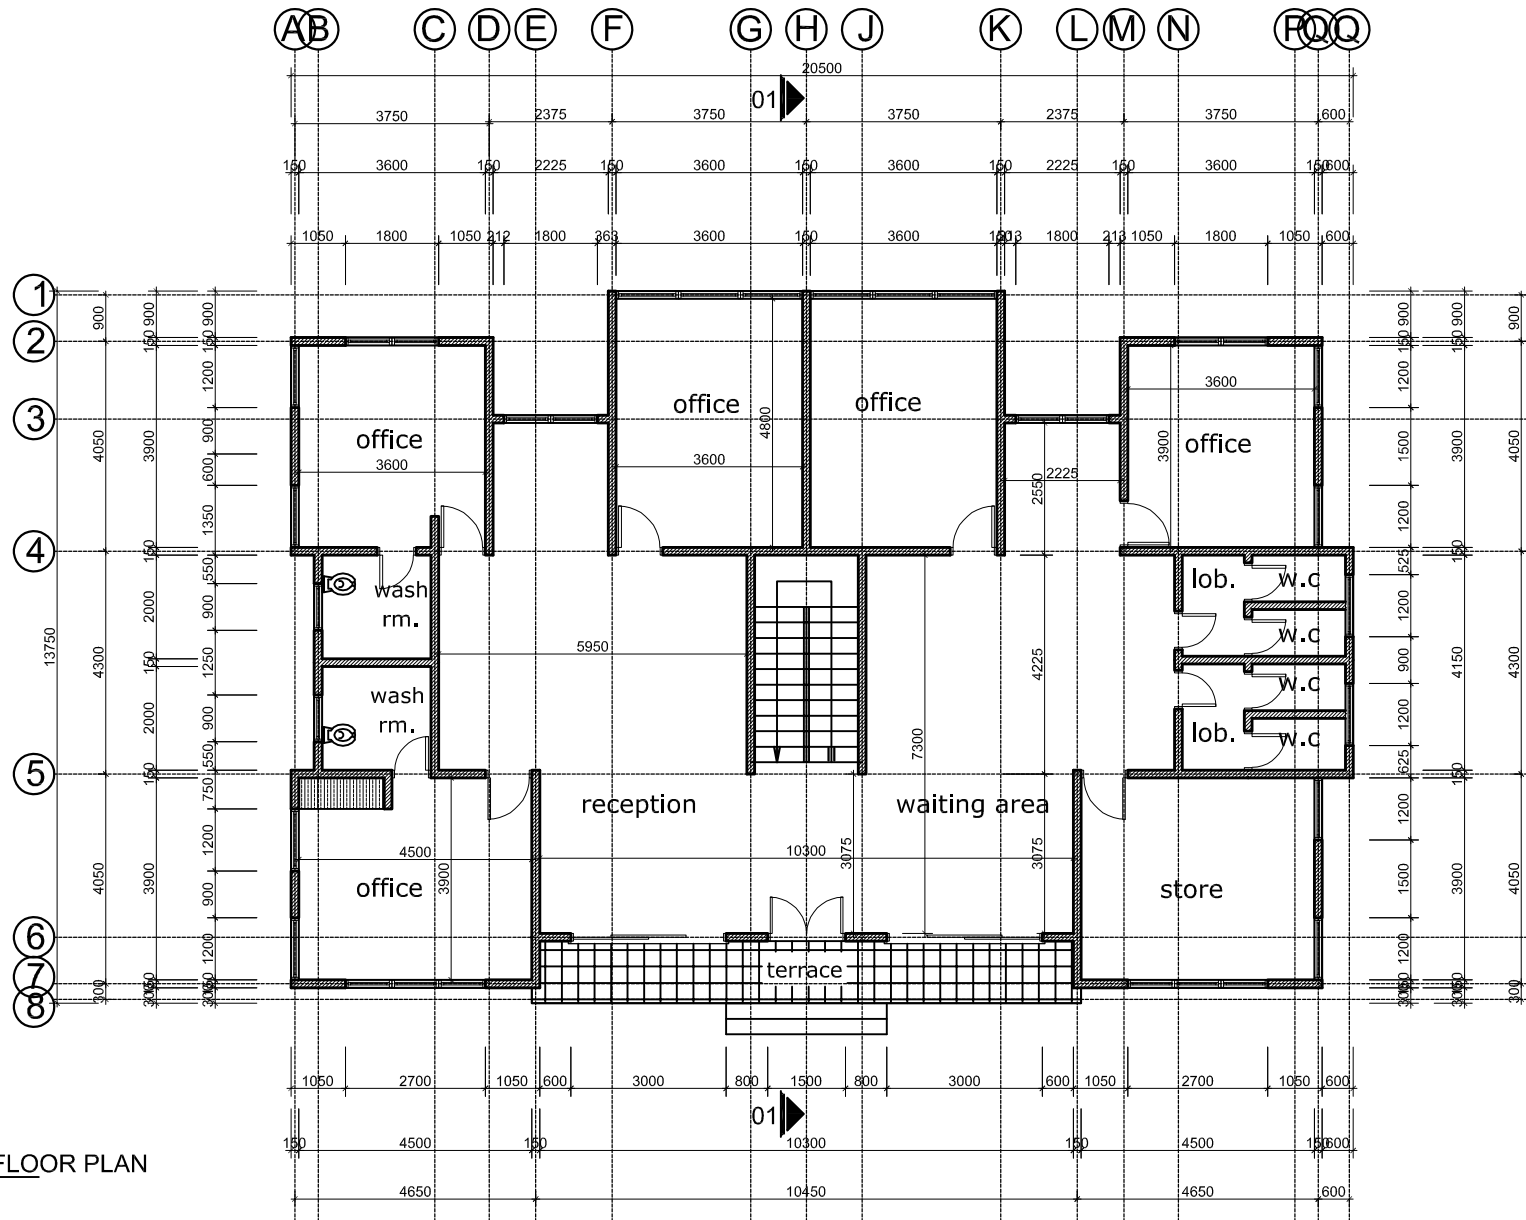

**GROUND FLOOR PLAN**  
SCALE 1:100

**NOTES**

Do not scale dimensions from drawings. Contractors, Sub-Contractors and Suppliers must verify all dimensions before commencing any work or making any shop drawings.

Should any divergence in dimensions occur between architectural, engineering or Sub-Contractors drawings, the Contractor shall immediately contact the Architect for clarification.


NO.	DESCRIPTION	DESIGN	CHECK	APPROVED	DATE

CLIENT:	<b>ANSAH AGYEMANG BARIMAH AND RITA AGYEMANG BARIMAH</b>
LOCATION:	<b>ADWEMADOR - GREATER ACCRA REGION</b>

PROJECT:	<b>PROPOSED FIVE STOREY ADMINISTRATION BLOCK</b>
DRAWING TITLE:	<b>AS INDICATED</b>

CHECKED BY:	
DESIGNED BY:	NICHOLAS
DRAWN BY:	NICHOLAS
DATE:	NOV.2021
SCALE:	1:100 & 1:25
SHEET No.:	012

**DRG. no.**  
**AR.02**  
SHE. SIZE -A3

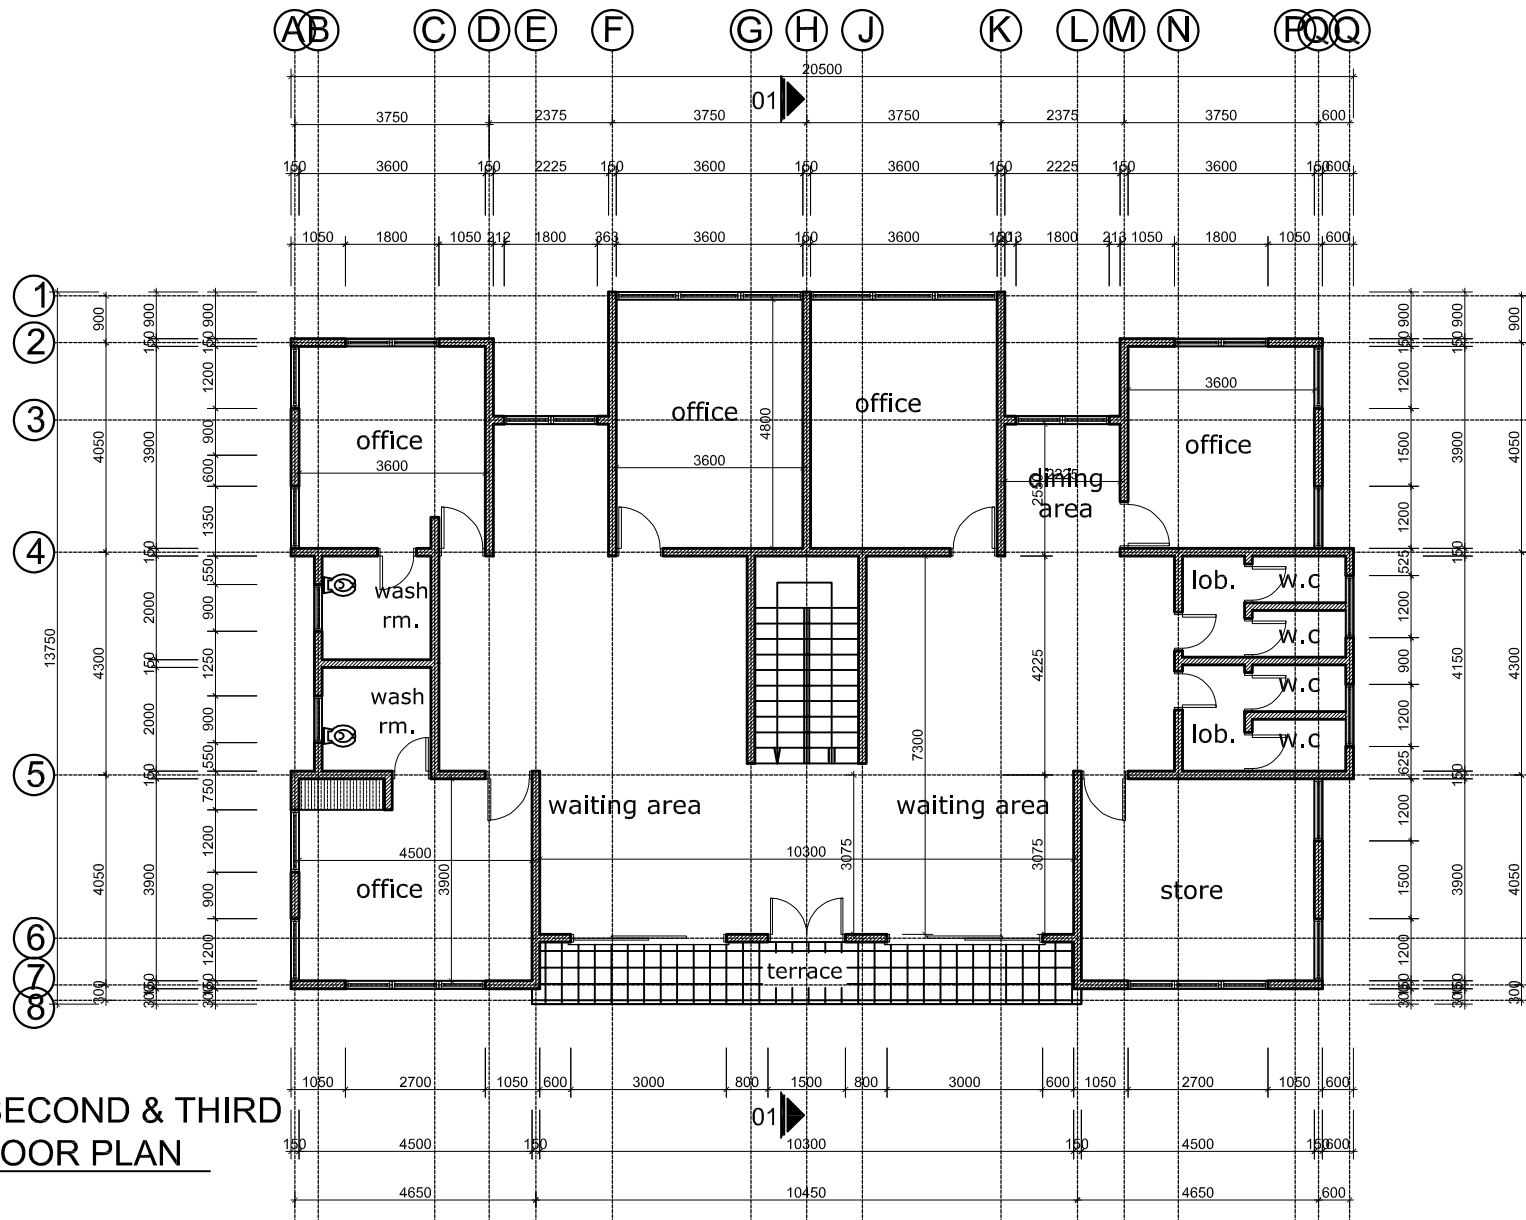

# FIRST, SECOND & THIRD FLOOR PLAN

SCALE 1:100

## NOTES

Do not scale dimensions from drawings. Contractors, Sub-Contractors and Suppliers must verify all dimensions before commencing any work or making any shop drawings. Should any divergence in dimensions occur between architectural, engineering or Sub-Contractors drawings, the Contractor shall immediately contact the Architect for clarification.


CLIENT: ANSAH AGYEMANG BARIMAH AND RITA AGYEMANG BARIMAH  
 LOCATION: ADWEMADOR - GREATER ACCRA REGION

PROJECT: PROPOSED FIVE STOREY ADMINISTRATION BLOCK  
 DRAWING TITLE: AS INDICATED

CHECKED BY:  
 DESIGNED BY: NICHOLAS  
 DRAWN BY: NICHOLAS  
 DATE: NOV. 2021  
 SCALE: 1:100 & 1:25  
 SHEET No.: 012

Dr. no.  
**AR.03**  
 SHE. SIZE -A3

NO.	DESCRIPTION	DESIGN	CHECK	APPROVED	DATE

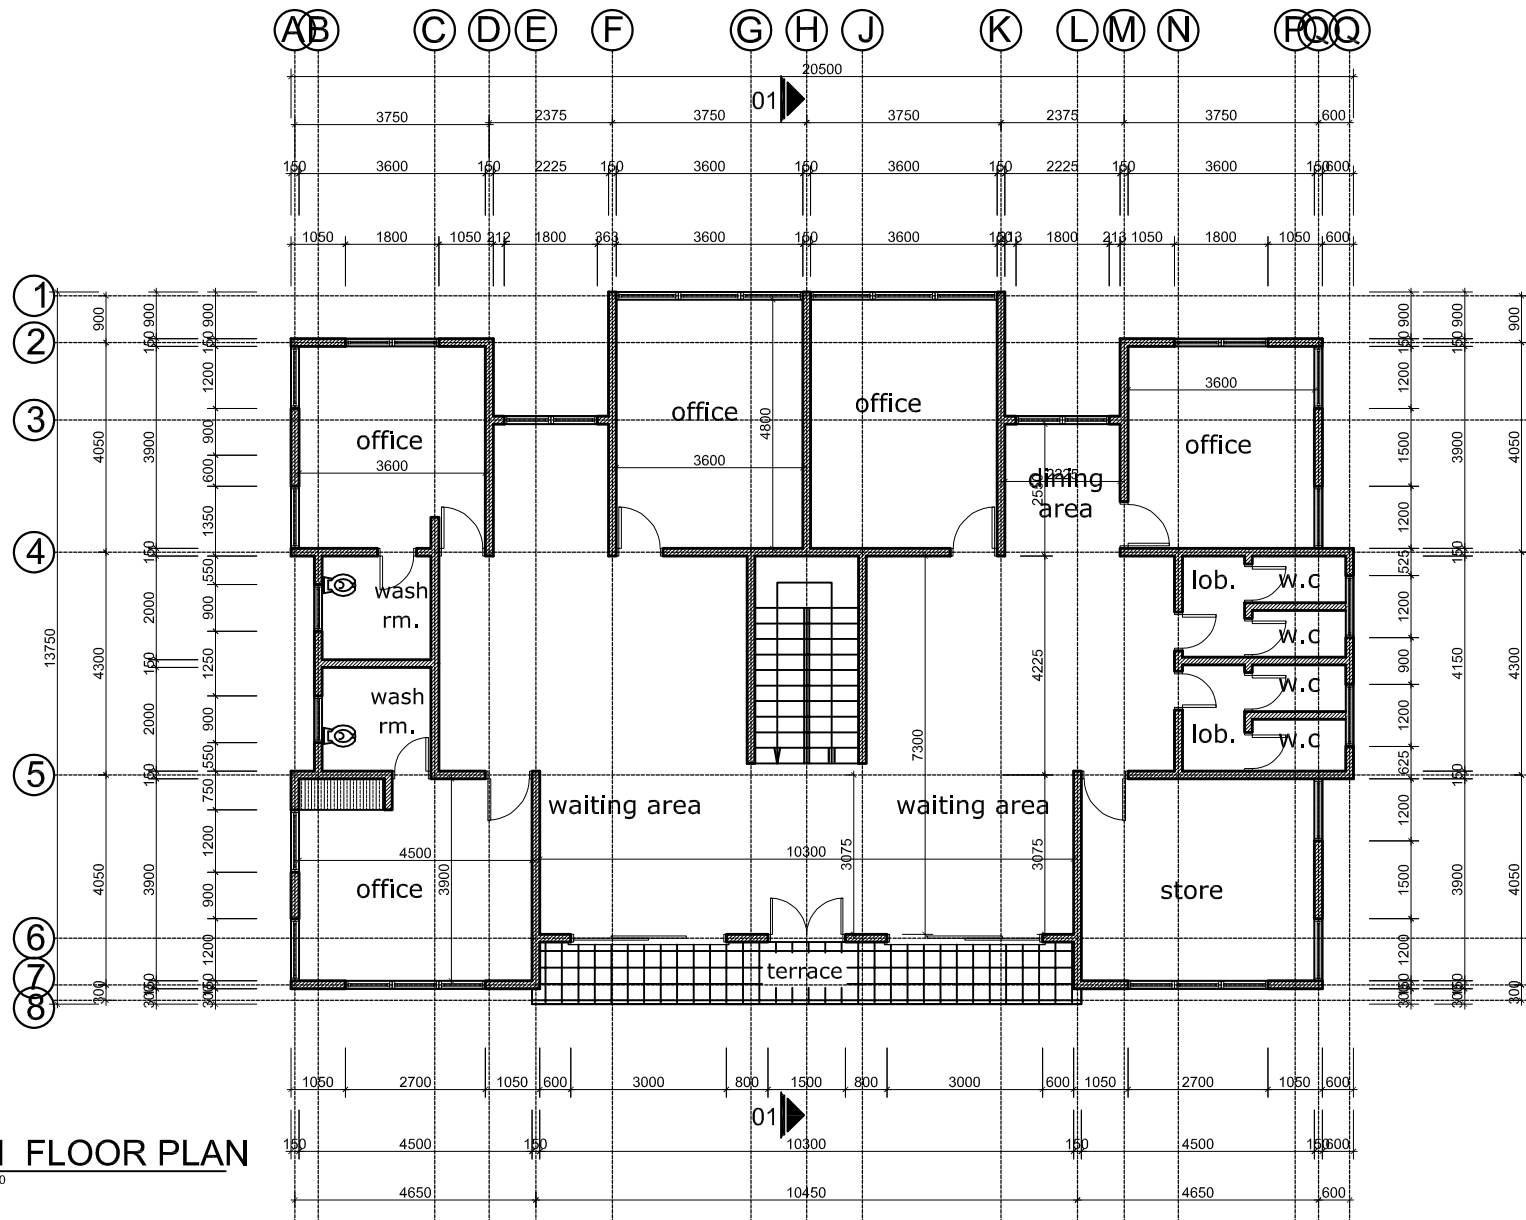

**FOURTH FLOOR PLAN**  
SCALE 1:100

NO.	DESCRIPTION	DESIGN	CHECK	APPROVED	DATE

**NOTES**

Do not scale dimensions from drawings. Contractors, Sub-Contractors and Suppliers must verify all dimensions before commencing any work or making any shop drawings.

Should any divergence in dimensions occur between architectural, engineering or Sub-Contractors drawings, the Contractor shall immediately contact the Architect for clarification.

CLIENT: **ANSAH AGYEMANG BARIMAH AND RITA AGYEMANG BARIMAH**

LOCATION: **ADWEMADOR - GREATER ACCRA REGION**

PROJECT: **PROPOSED FIVE STOREY ADMINISTRATION BLOCK**

DRAWING TITLE: **AS INDICATED**

CHECKED BY: \_\_\_\_\_

DESIGNED BY: NICHOLAS

DRAWN BY: NICHOLAS


DATE: NOV.2021

SCALE: 1:100 & 1:25

SHEET No.: 012

Dr. no. **AR.04**

SHE. SIZE -A3

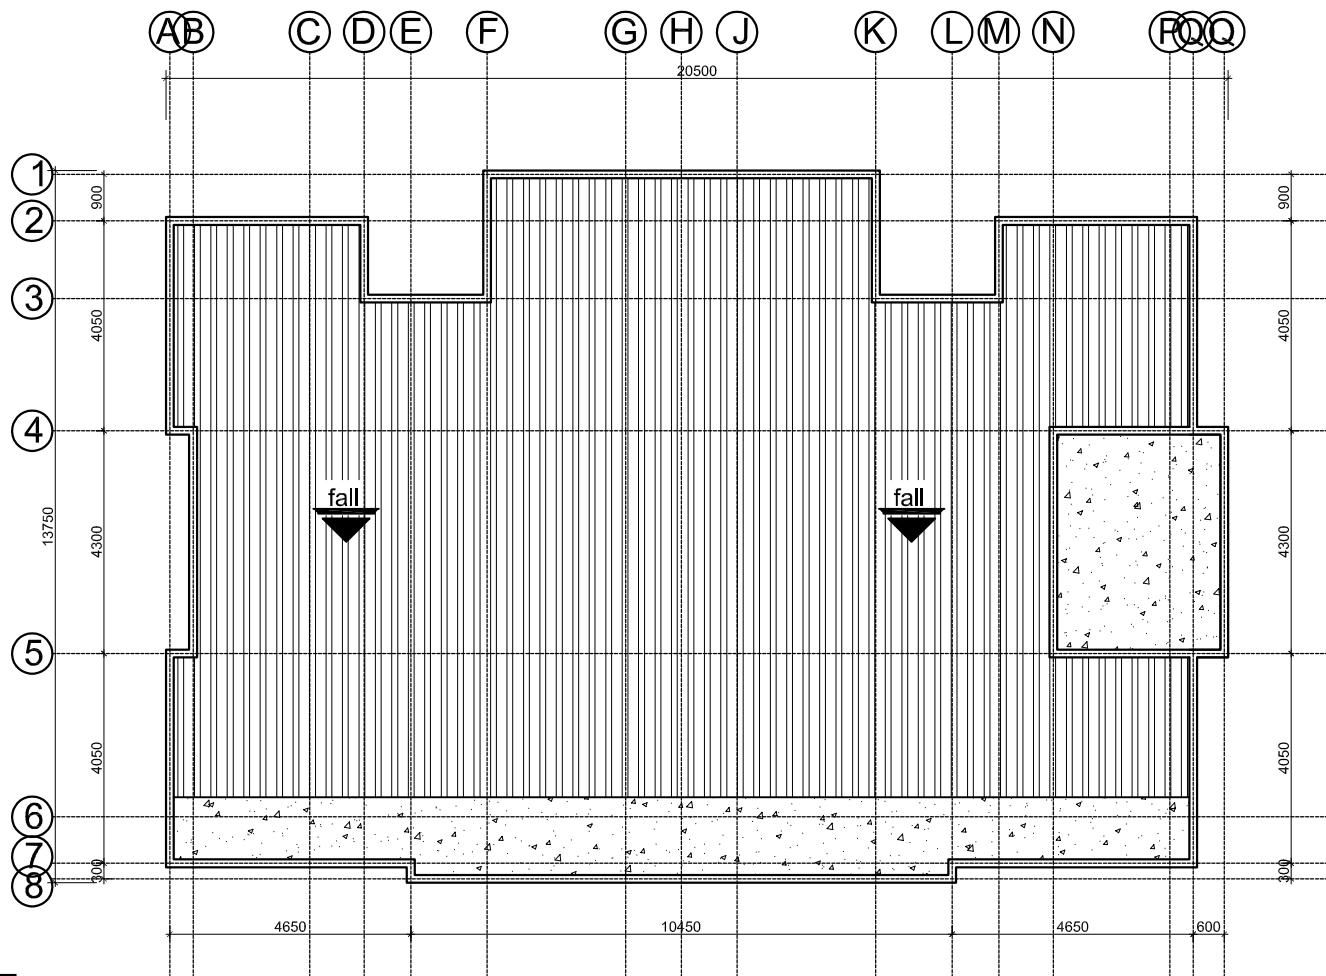

**ROOF FRAME**  
SCALE 1:100

NO.	DESCRIPTION	DESIGN	CHECK	APPROVED	DATE

**NOTES**

Do not scale dimensions from drawings. Contractors, Sub-Contractors and Suppliers must verify all dimensions before commencing any work or making any shop drawings.

Should any divergence in dimensions occur between architectural, engineering or Sub-Contractors drawings, the Contractor shall immediately contact the Architect for clarification.

CLIENT: **ANSAH AGYEMANG BARIMAH AND RITA AGYEMANG BARIMAH**

LOCATION: **ADWEMADOR -GREATER ACCRA REGION**

PROJECT: **PROPOSED FIVE STOREY ADMINISTRATION BLOCK**

DRAWING TITLE: **AS INDICATED**

CHECKED BY: \_\_\_\_\_

DESIGNED BY: NICHOLAS

DRAWN BY: NICHOLAS



DATE: NOV.2021

SCALE: 1:100 & 1:25


SHEET No.: 012

Drg. no. **AR.05**

SHE. SIZE -A3

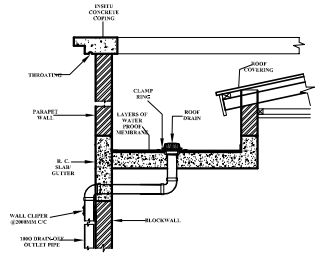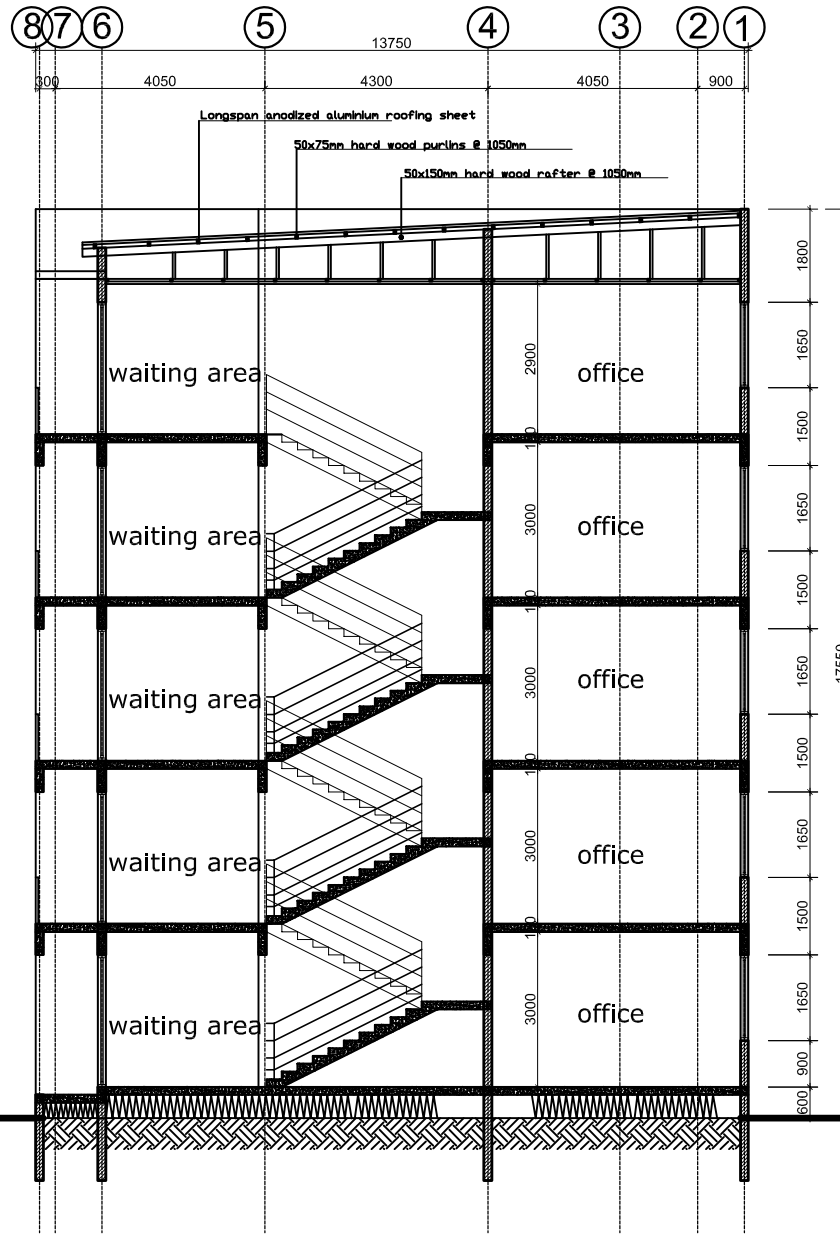

**TYPICAL DRAIN-OFF DETAIL A @ EAVES**

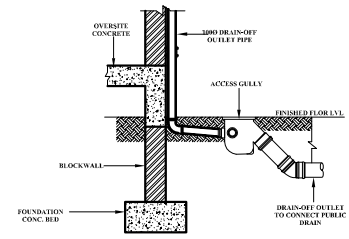

**TYPICAL DRAIN-OFF DETAIL B @ FLINTH BASE**

**SECTION 01-01**  
scale: 1/100

**NOTES**

Do not scale dimensions from drawings. Contractors, Sub-Contractors and Suppliers must verify all dimensions before commencing any work or making any shop drawings.

Should any divergence in dimensions occur between architectural, engineering or Sub-Contractors drawings, the Contractor shall immediately contact the Architect for clarification.

CLIENT: **ANSAH AGYEMANG BARIMAH AND RITA AGYEMANG BARIMAH**

LOCATION: **ADWEMADOR - GREATER ACCRA REGION**

PROJECT: **PROPOSED FIVE STOREY ADMINISTRATION BLOCK**

DRAWING TITLE: **AS INDICATED**

CHECKED BY: \_\_\_\_\_

DESIGNED BY: **NICHOLAS**

DRAWN BY: **NICHOLAS**

DATE: **NOV.2021**


SCALE: **1:100 & 1:25**

SHEET No.: **012**

Dr. no. **AR.06**

SHE. SIZE -A3

NO.	DESCRIPTION	DESIGN	CHECK	APPROVED	DATE

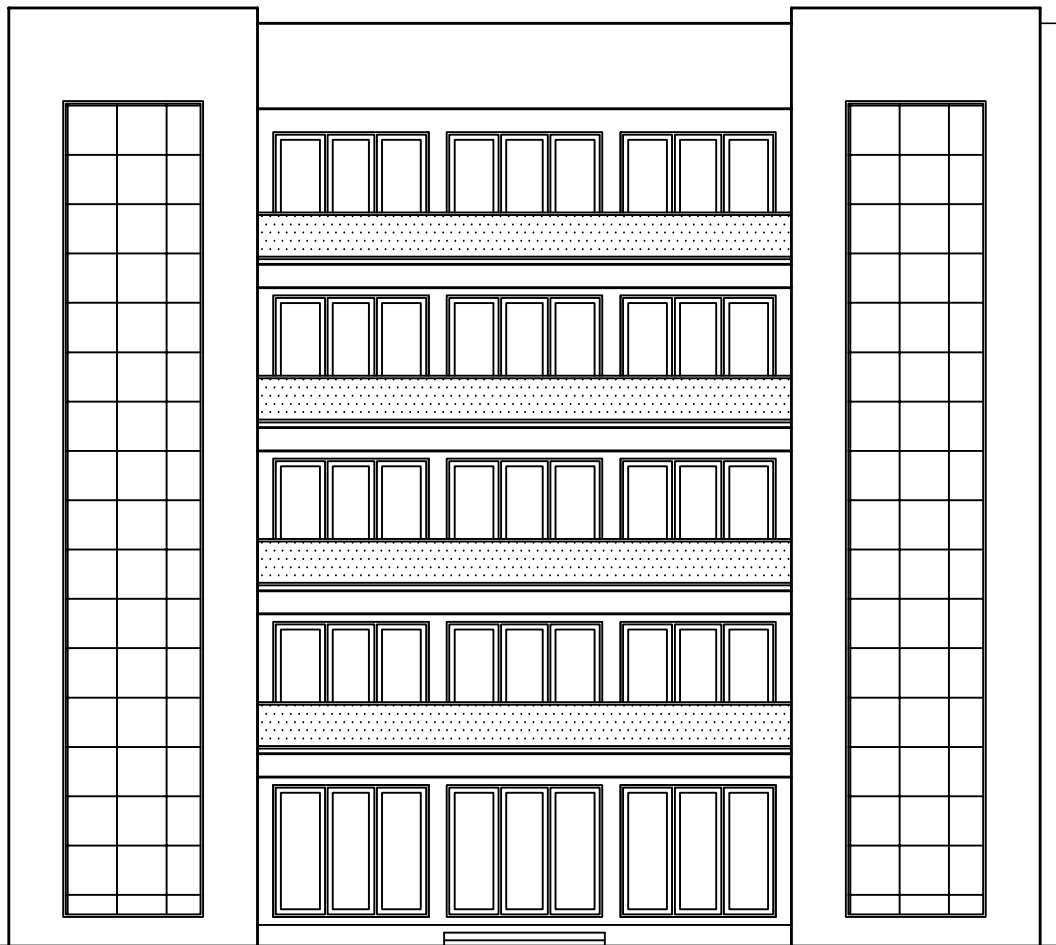

**FRONT ELEVATION**

SCALE 1:100

**NOTES**

Do not scale dimensions from drawings. Contractors, Sub-Contractors and Suppliers must verify all dimensions before commencing any work or making any shop drawings.

Should any divergence in dimensions occur between architectural, engineering or Sub-Contractors drawings, the Contractor shall immediately contact the Architect for clarification


NO.	DESCRIPTION	DESIGN	CHECK	APPROVED	DATE

CLIENT:	<b>ANSAH AGYEMANG BARIMAH AND RITA AGYEMANG BARIMAH</b>
LOCATION:	<b>ADWEMADOR -GREATER ACCRA REGION</b>

PROJECT:	<b>PROPOSED FIVE STOREY ADMINISTRATION BLOCK</b>
DRAWING TITLE:	<b>AS INDICATED</b>


CHECKED BY:	
DESIGNED BY:	NICHOLAS
DRAWN BY:	NICHOLAS
DATE:	NOV.2021
SCALE:	1:100 & 1:25
SHEET No.:	012

**Drg. no.**  
**AR.07**  
SHE. SIZE -A3

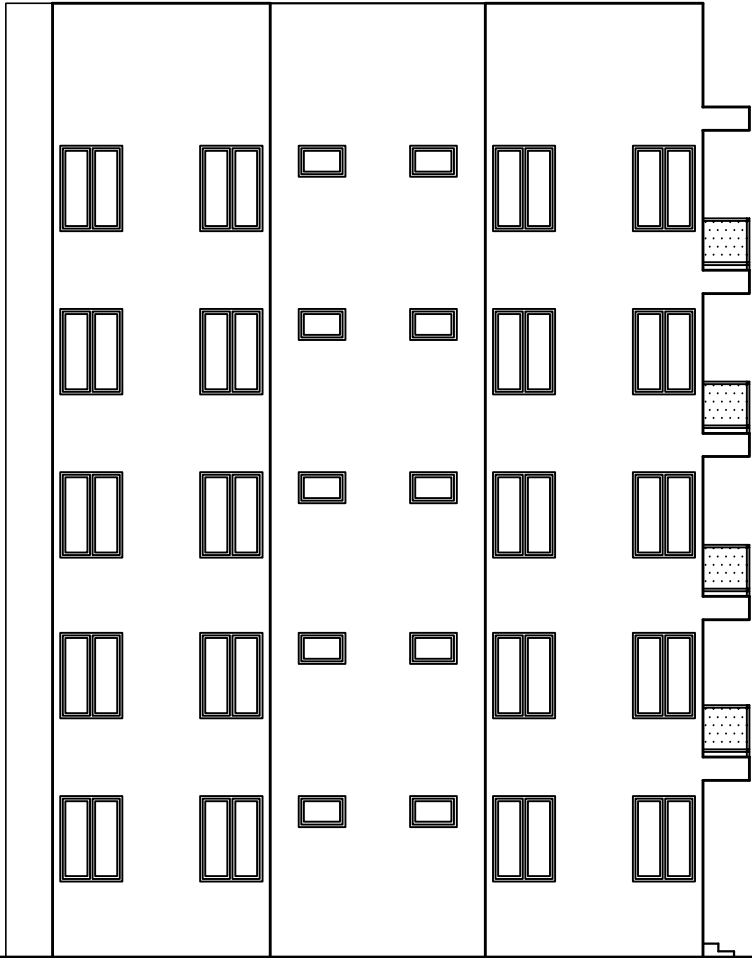

**RIGHT SIDE ELEVATION**

SCALE 1:100

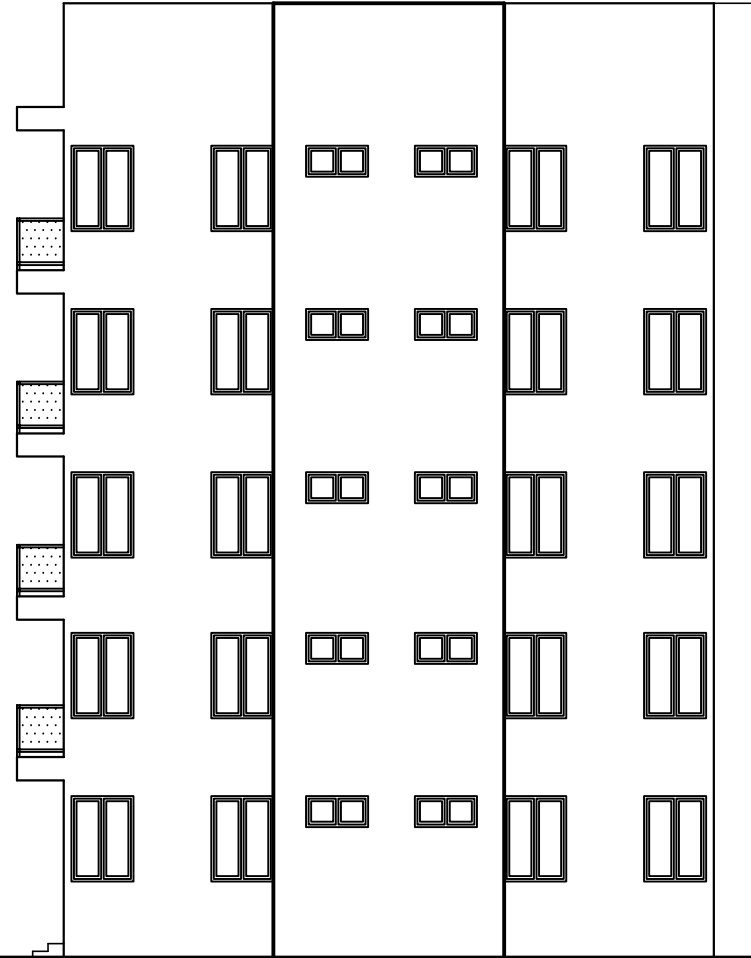

**LIFT SIDE ELEVATION**

SCALE 1:100

**NOTES**

Do not scale dimensions from drawings. Contractors, Sub-Contractors and Suppliers must verify all dimensions before commencing any work or making any shop drawings. Should any divergence in dimensions occur between architectural, engineering or Sub-Contractors drawings, the Contractor shall immediately contact the Architect for clarification.


NO.	DESCRIPTION	DESIGN	CHECK	APPROVED	DATE

CLIENT:	ANSAH AGYEMANG BARIMAH AND RITA AGYEMANG BARIMAH
LOCATION:	ADWEMADOR -GREATER ACCRA REGION

PROJECT:	PROPOSED FIVE STOREY ADMINISTRATION BLOCK
DRAWING TITLE:	AS INDICATED

CHECKED BY:	DESIGNED BY: NICHOLAS	Drg. no. <b>AR.08</b>
DRAWN BY: NICHOLAS	DATE: NOV.2021	
SCALE: 1:100 & 1:25	SHEET No.: 012	
SHEET No.: 012	SHE. SIZE -A3	



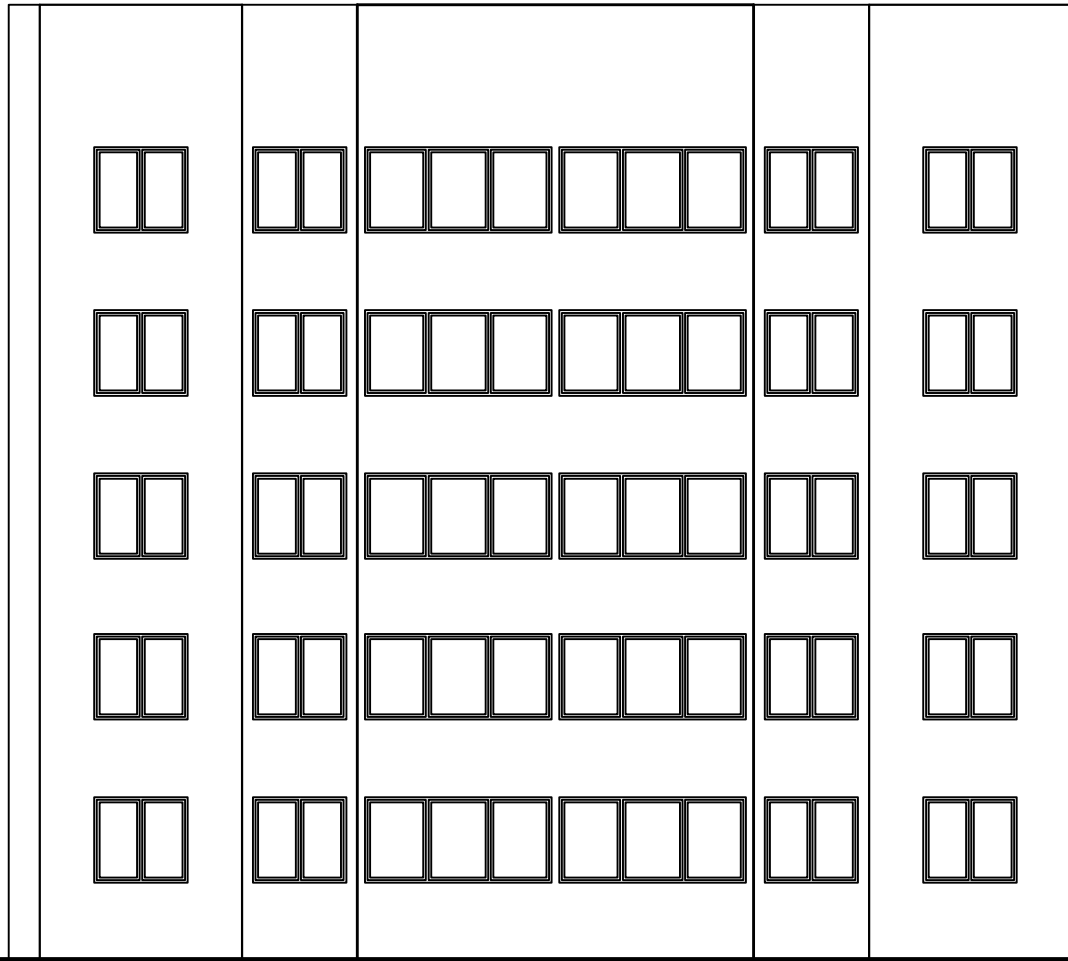

**BACK ELEVATION**  
SCALE 1:100

NO.	DESCRIPTION	DESIGN	CHECK	APPROVED	DATE

**NOTES**

Do not scale dimensions from drawings. Contractors, Sub-Contractors and Suppliers must verify all dimensions before commencing any work or making any shop drawings.

Should any divergence in dimensions occur between architectural, engineering or Sub-Contractors drawings, the Contractor shall immediately contact the Architect for clarification.

CLIENT: **ANSAH AGYEMANG BARIMAH AND RITA AGYEMANG BARIMAH**

LOCATION: **ADWEMADOR -GREATER ACCRA REGION**

PROJECT: **PROPOSED FIVE STOREY ADMINISTRATION BLOCK**

DRAWING TITLE: **AS INDICATED**

CHECKED BY: \_\_\_\_\_

DESIGNED BY: NICHOLAS

DRAWN BY: NICHOLAS


DATE: NOV.2021

SCALE: 1:100 & 1:25

SHEET No.: 012

Drg. no. **AR.09**

SHE. SIZE -A3

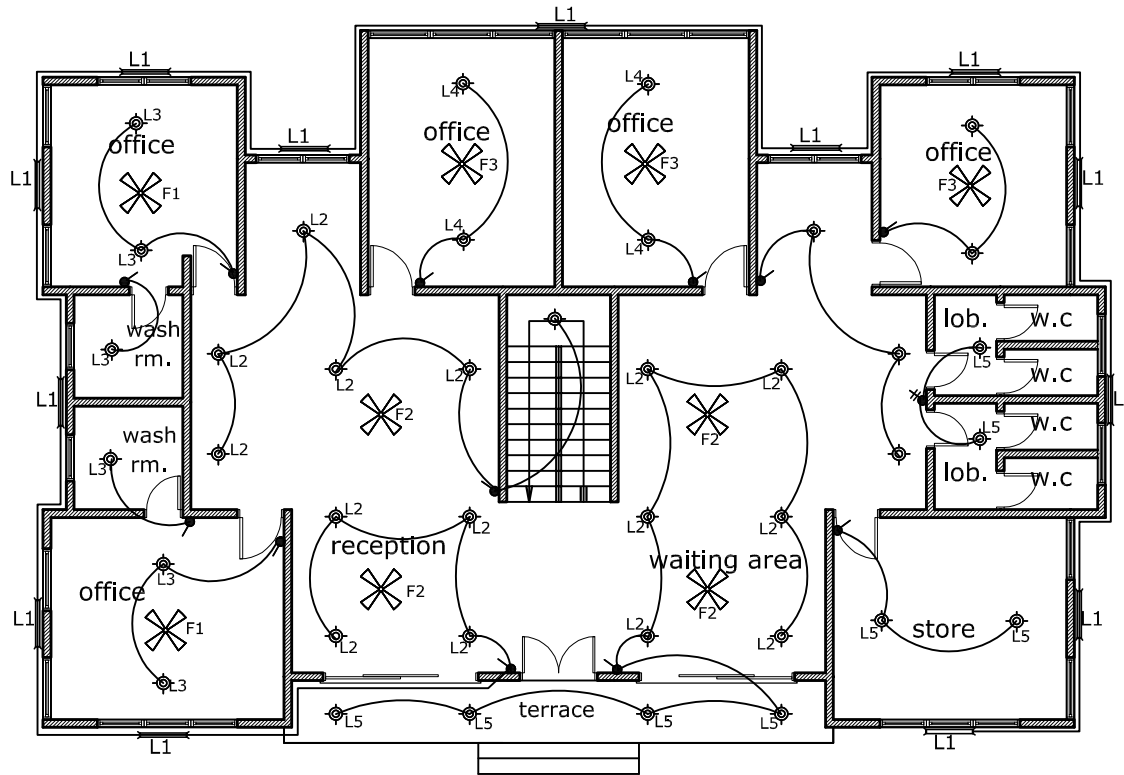

LEGEND		
SYMBOLS	NAMES	QUAN.
	ONE WAY 5-AMPS LIGHTING SWITCH	15
	TWO WAY 5-AMPS LIGHTING SWITCH	4
	THREE WAY 5-AMPS LIGHTING SWITCH	4
	DOUBLE GANG LIGHTING SWITCH	0
	SURFACE MOUNTED CEILING LIGHTING	13
	RECESSED LIGHT	17
	THREE IN ONE SQUARE RECESSED LIGHT	55
	WALL GLOBE AND BRACKET LIGHTING UNIT	0
	DOUBLE 13-AMPS SWITCH SOCKET UNIT	15
	13-AMPS SWITCH SOCKET UNIT	9
	15-AMPS SWITCH SOCKET UNIT	15
	WARDROBE HEATER	0
	TELEPHONE POINT	5
	HEATER AND COOKER CONTROL	1
	1200mm FLUORESCENT FITTING	23
	CHANDELIER LIGHT FITTING	0
	METER BOARD	2
	DISTRIBUTION BOARD	
	EARTH POINT	4
	CEILING SWITCH	25
	CEILING FAN	25
	AIRCONDITION OUTLET AND SWITCH	
NOTE	ALL THE WIRING SHOULD BE LAID IN CONDUIT	

**GROUND FLOOR  
ELECTRICAL LAYOUT**  
SCALE 1:100

**NOTES**

Do not scale dimensions from drawings. Contractors, Sub-Contractors and Suppliers must verify all dimensions before commencing any work or making any shop drawings.

Should any divergence in dimensions occur between architectural, engineering or Sub-Contractors drawings, the Contractor shall immediately contact the Architect for clarification.

NO.	DESCRIPTION	DESIGN	CHECK	APPROVED	DATE



 








CLIENT:	ANSAH AGYEMANG BARIMAH AND RITA AGYEMANG BARIMAH
LOCATION:	ADWEMADOR -GREATER ACCRA REGION


PROJECT:	PROPOSED FIVE STOREY ADMINISTRATION BLOCK
DRAWING TITLE:	AS INDICATED

CHECKED BY:	DESIGNED BY: NICHOLAS	Drg. no. <b>AR.11</b>
DRAWN BY: NICHOLAS	DATE: NOV.2021	
SCALE: 1:100 & 1:25		
SHEET No.: 012	SHE. SIZE -A3	



### LEGEND

-  WAST WATER PIPE LINE
-  INSPECTION CHAMBER PIPE LINE
-  COLD WATER PIPE LINE
-  COMBINED HOSE REEL/HVDR RISER CABINET
-  GATE VALVE
-  WATER METER
-  STOP CORK
-  WATER CLOSET
-  DOMESTIC WASH BASIN
-  SHOWER TRAY
-  KITCHEN SINK UNIT.

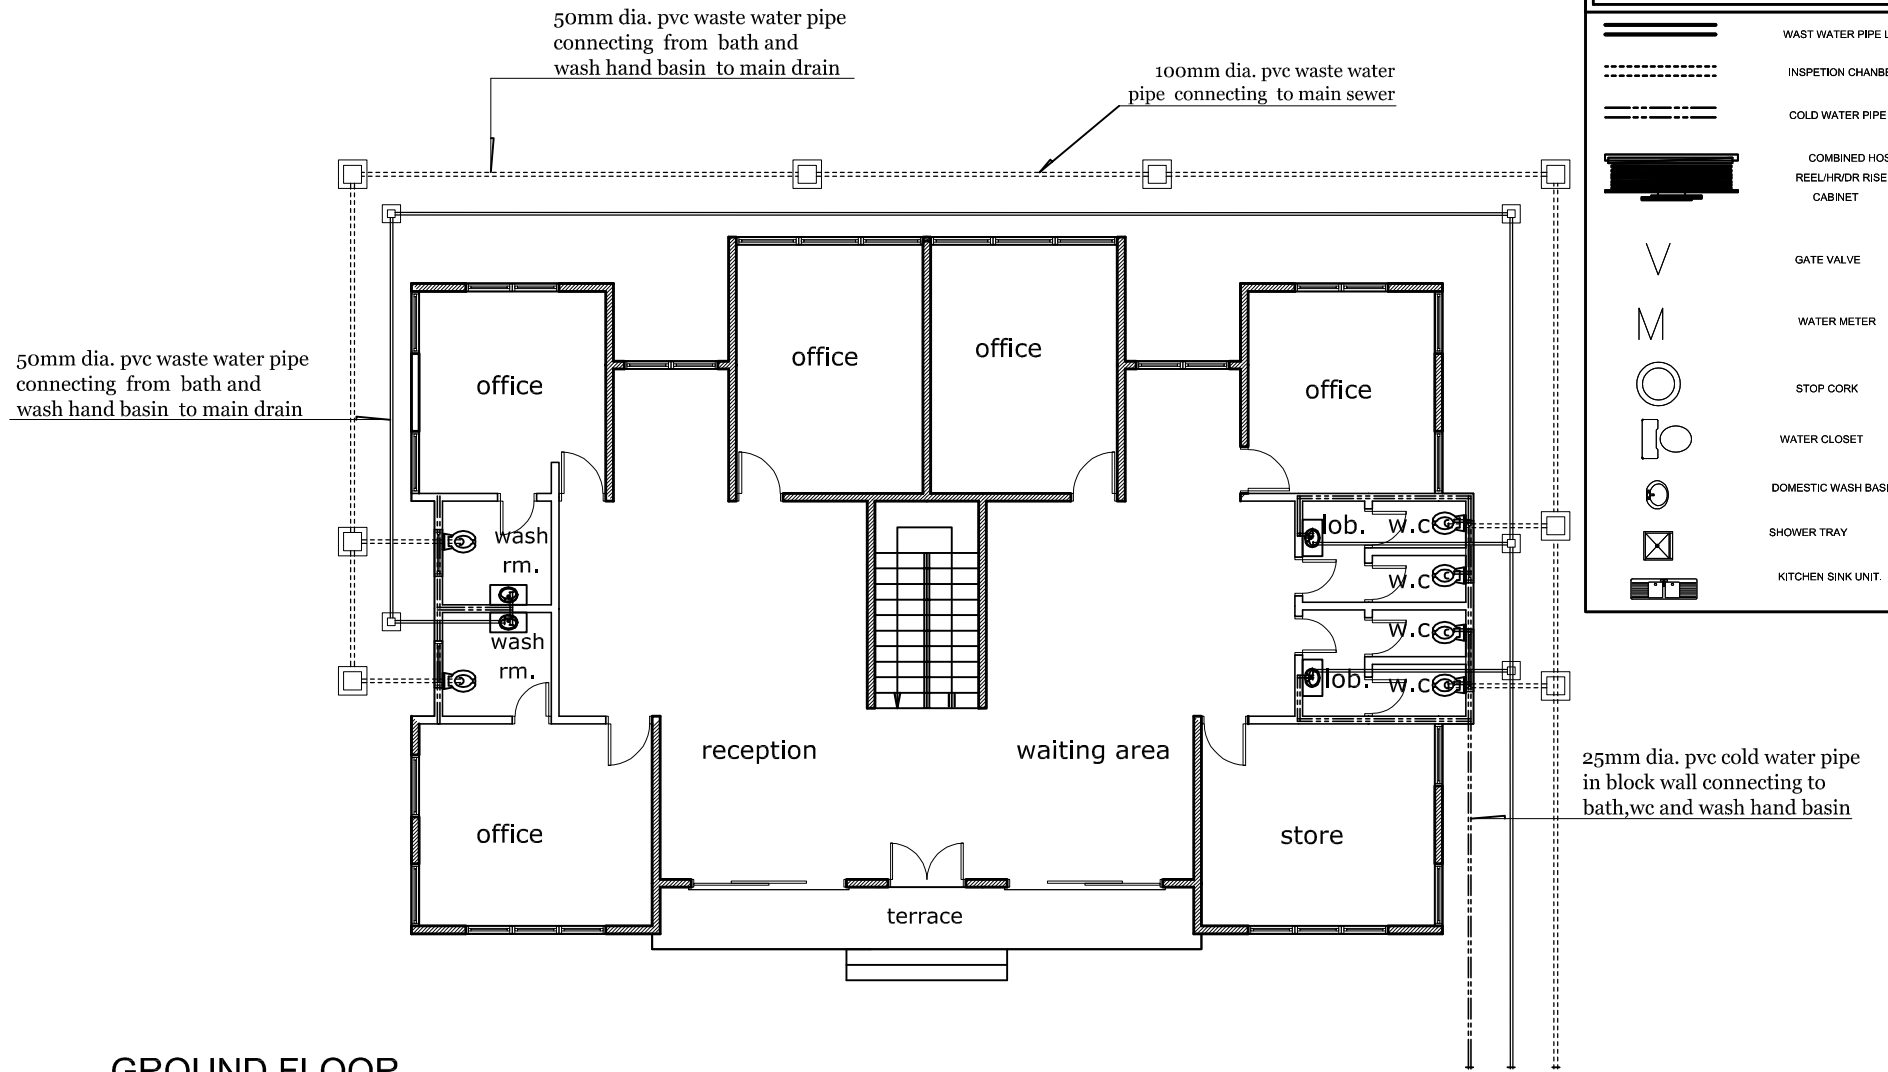

## GROUND FLOOR PLUMBING LAYOUT

NO.	DESCRIPTION	DESIGN	CHECK	APPROVED	DATE

**NOTES**

Do not scale dimensions from drawings. Contractors, Sub-Contractors and Suppliers must verify all dimensions before commencing any work or making any shop drawings.

Should any divergence in dimensions occur between architectural, engineering or Sub-Contractors drawings, the Contractor shall immediately contact the Architect for clarification.

CLIENT: **ANSAH AGYEMANG BARIMAH AND RITA AGYEMANG BARIMAH**

LOCATION: **ADWEMADOR -GREATER ACCRA REGION**

PROJECT: **PROPOSED FIVE STOREY ADMINISTRATION BLOCK**

DRAWING TITLE: **AS INDICATED**

CHECKED BY: \_\_\_\_\_

DESIGNED BY: **NICHOLAS**

DRAWN BY: **NICHOLAS**

DATE: **NOV.2021**


 
 








SCALE: **1:100 & 1:25**


SHEET No.: **012**

Drg. no.  
**AR.14**

SHE. SIZE -A3

### LEGEND

-  WAST WATER PIPE LINE
-  INSPETION CHANBER PIPE LINE
-  COLD WATER PIPE LINE
-  COMBINED HOSE REEL/HVDR RISER CABINET
-  GATE VALVE
-  WATER METER
-  STOP CORK
-  WATER CLOSET
-  DOMESTIC WASH BASIN
-  SHOWER TRAY
-  KITCHEN SINK UNIT.

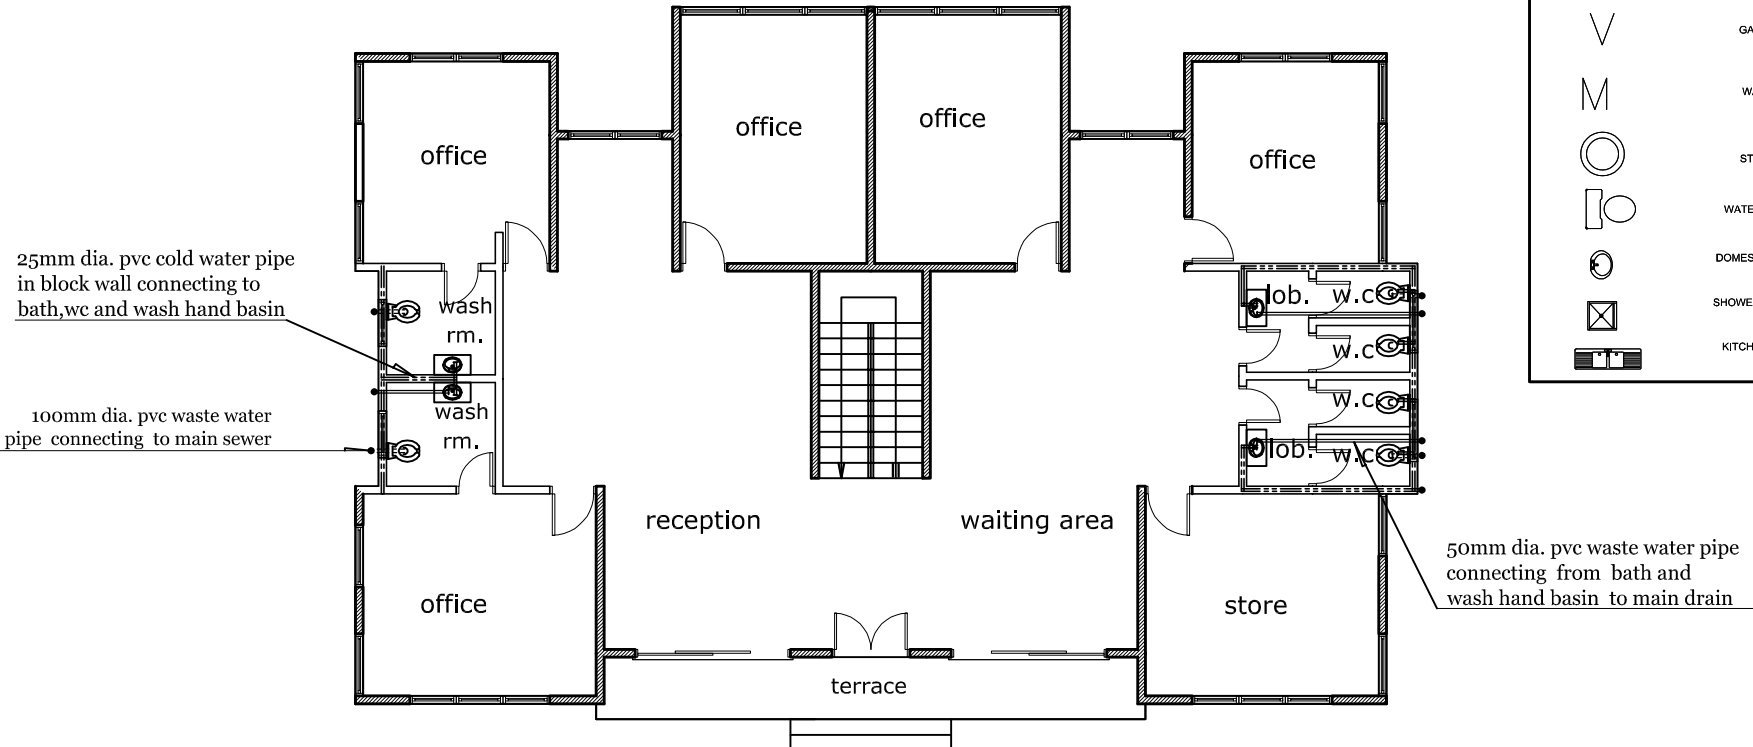


## FIRST , SECOND,THIRD & FOURTH FLOOR PLUMBING LAYOUT

SCALE 1:100

<p><b>NOTES</b></p> <p>Do not scale dimensions from drawings. Contractors, Sub-Contractors and Suppliers must verify all dimensions before commencing any work or making any shop drawings.</p> <p>Should any divergence in dimensions occur between architectural, engineering or Sub-Contractors drawings, the Contractor shall immediately contact the Architect for clarification.</p>						CLIENT: ANSAH AGYEMANG BARIMAH AND RITA AGYEMANG BARIMAH		PROJECT: PROPOSED FIVE STOREY ADMINISTRATION BLOCK		CHECKED BY:	
						LOCATION: ADWEMADOR -GREATER ACCRA REGION		DRAWING TITLE: AS INDICATED		DESIGNED BY: NICHOLAS	
NO.		DESCRIPTION		DESIGN		DRAWN BY: NICHOLAS					
						DATE: NOV.2021					
						SCALE: 1:100 & 1:25					
						SHEET No.: 012					
						SHE. SIZE -A3					


**SEPTIC TANK NOTES**

- I. air should be excluded from tank to encourage growth of anaerobic bacteria required to liquify the sludge and facilitate flow of effluent
- II. accumulated gases are expected to be expelled through vent at least 600mm above eaves with open ends protected against nesting birds
- III. drain should be given sufficient fall ( e.g 1 in 40 for 100mm dia. pipe )
- IV. joints should be properly made to prevent blocking of the aperture
- V. septic tank must be constructed in concrete with the top at least 150mm above ground level
- VI. overall depth of septic tank below ground level is determined by the inlet and shall not be less than 1800mm the depth below inlet level shall also be 1400 – 1500mm and any case not less than 1200mm
- VII. baffle screens must be provided to prevent direct flow between inlet and outlet
- VIII. septic tank should be open every six months and depth of top crust ascertained if this exceeds 30cm surplus should be removed and buried

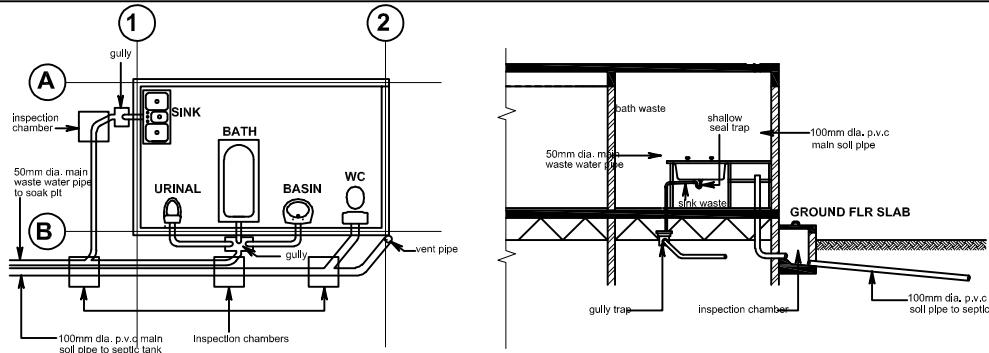


**SCHMATIC PLAN**


**SCHMATIC SECTION**

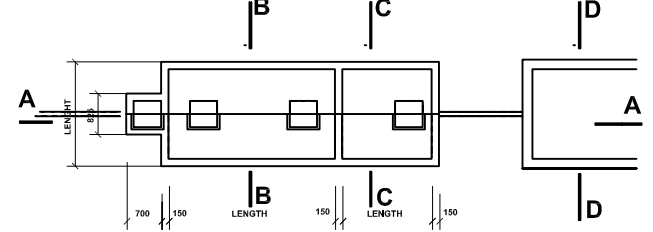


**FLOOR PLAN**

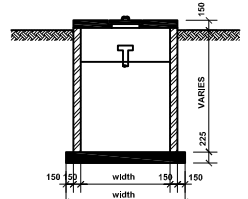

**SECTION B - B**

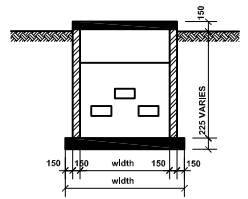


**SECTION C - C**

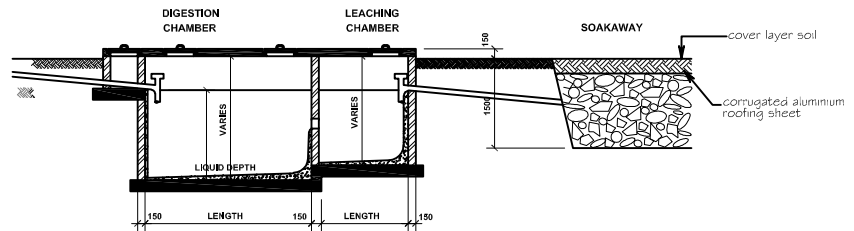


**SECTION A - A**


**FENCE WALL DETAILS**

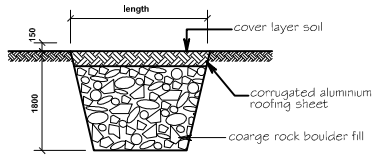


**SECTION D - D**

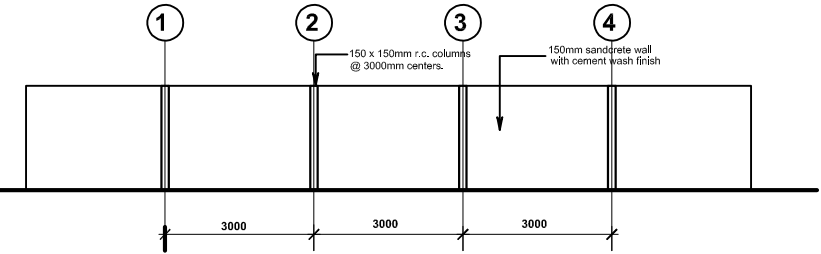


**ELEVATION (side wall)**

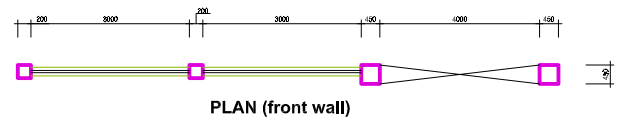

**PLAN (front wall)**

 

**ELEVATION (front wall)**

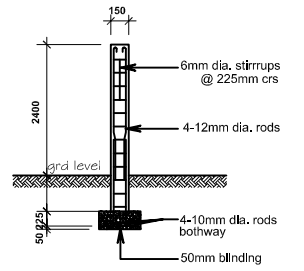

**COLUMN SECTION**

**○ fence wall & SEPTIC TANK**

**NOTES**

Do not scale dimensions from drawings. Contractors, Sub-Contractors and Suppliers must verify all dimensions before commencing any work or making any shop drawings. Should any divergence in dimensions occur between architectural, engineering or Sub-Contractors drawings, the Contractor shall immediately contact the Architect for clarification


CLIENT:	ANSAH AGYEMANG BARIMAH AND RITA AGYEMANG BARIMAH
LOCATION:	ADWEMADOR -GREATER ACCRA REGION

PROJECT:	PROPOSED FIVE STOREY ADMINISTRATION BLOCK
DRAWING TITLE:	AS INDICATED

CHECKED BY:	NICHOLAS
DESIGNED BY:	NICHOLAS
DRAWN BY:	NICHOLAS
DATE:	NOV.2021
SCALE:	1:100 & 1:25
SHEET No.:	012

NO.	DESCRIPTION	DESIGN	CHECK	APPROVED	DATE

**Dr. no.**  
**AR.16**  
SHE. SIZE -A3

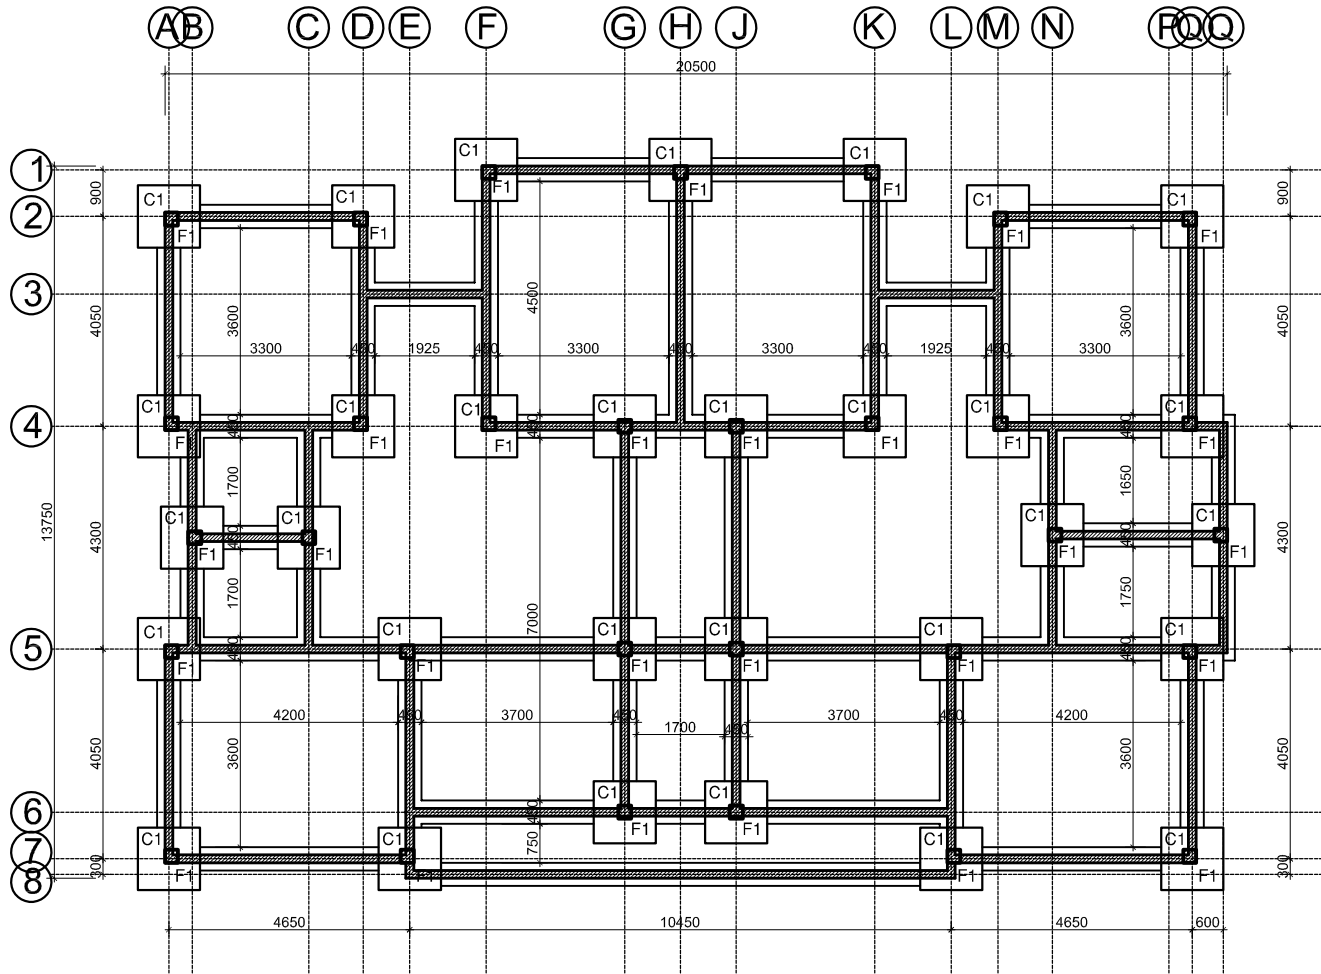

# FOUNDATION LAYOUT

SCALE = 1:100

## NOTES

Do not scale dimensions from drawings. Contractors, Sub-Contractors and Suppliers must verify all dimensions before commencing any work or making any shop drawings.

Should any divergence in dimensions occur between architectural, engineering or Sub-Contractors drawings, the Contractor shall immediately contact the Architect for clarification.


CLIENT: ANSAH AGYEMANG BARIMAH AND RITA AGYEMANG BARIMAH  
 LOCATION: ADWEMADOR -GREATER ACCRA REGION

PROJECT: PROPOSED FIVE STOREY ADMINISTRATION BLOCK  
 DRAWING TITLE: AS INDICATED

CHECKED BY:  
 DESIGNED BY: NICHOLAS  
 DRAWN BY: NICHOLAS  
 DATE: NOV.2021  
 SCALE: 1:100 & 1:25  
 SHEET No.: 012

Drg. no.  
**AR.17**  
 SHE. SIZE -A3

NO.	DESCRIPTION	DESIGN	CHECK	APPROVED	DATE

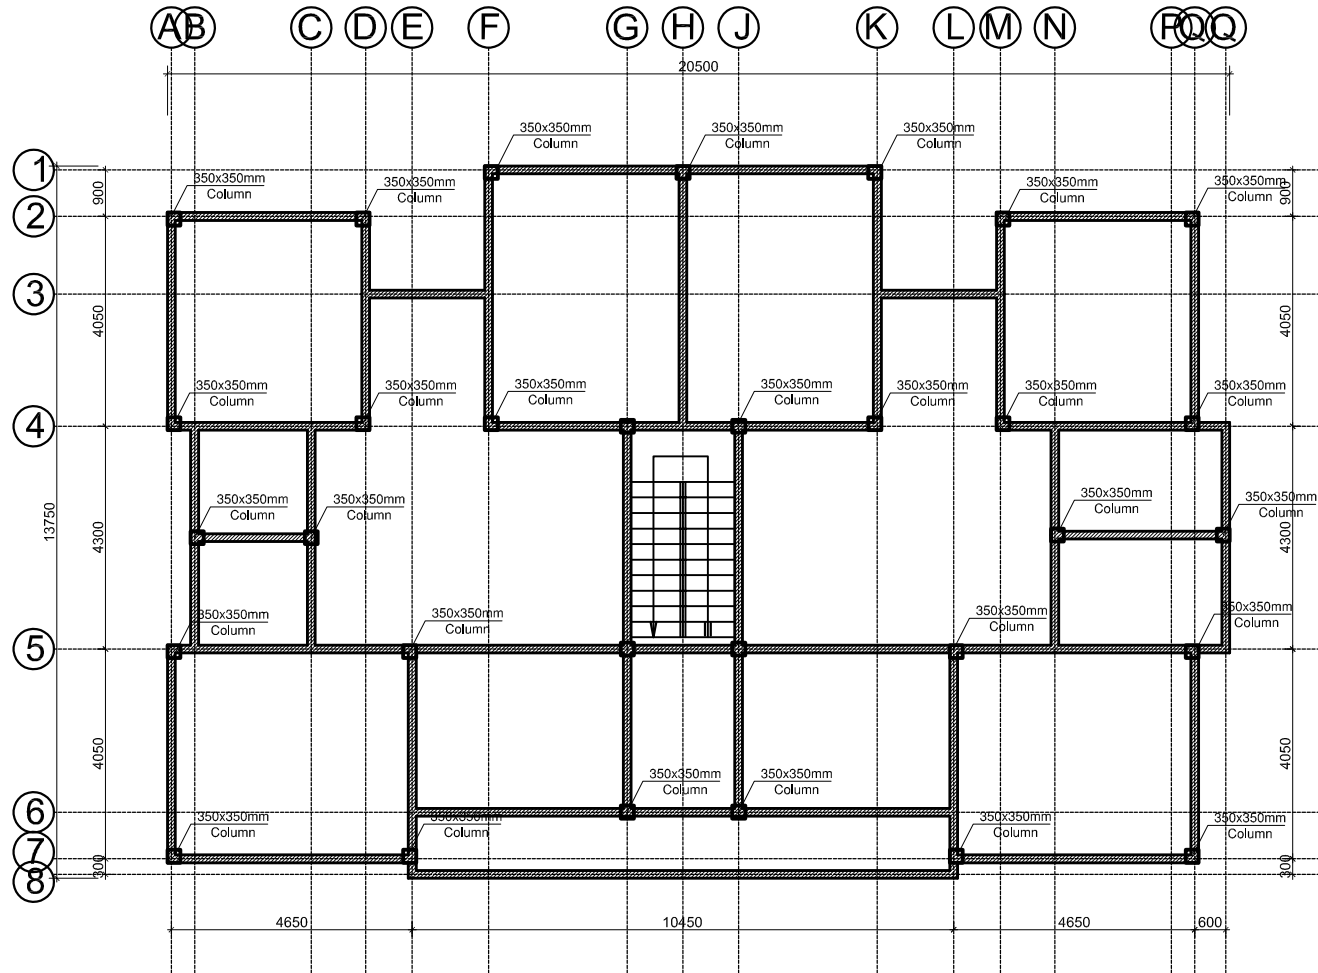

**GENERAL ARRANGEMENT OF R.C  
COLUMNS LAYOUT**

SCALE = 1:100

**NOTES**

Do not scale dimensions from drawings. Contractors, Sub-Contractors and Suppliers must verify all dimensions before commencing any work or making any shop drawings.

Should any divergence in dimensions occur between architectural, engineering or Sub-Contractors drawings, the Contractor shall immediately contact the Architect for clarification.

NO.	DESCRIPTION	DESIGN	CHECK	APPROVED	DATE





CLIENT:	<b>ANSAH AGYEMANG BARIMAH AND RITA AGYEMANG BARIMAH</b>
LOCATION:	<b>ADWEMADOR -GREATER ACCRA REGION</b>

PROJECT:	<b>PROPOSED FIVE STOREY ADMINISTRATION BLOCK</b>
DRAWING TITLE:	<b>AS INDICATED</b>


CHECKED BY:	
DESIGNED BY:	NICHOLAS
DRAWN BY:	NICHOLAS
DATE:	NOV.2021
SCALE:	1:100 & 1:25
SHEET No.:	012

**Drg. no.**  
**AR.18**  
SHE. SIZE -A3




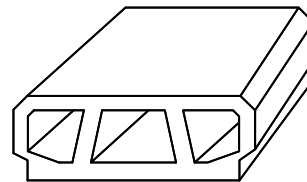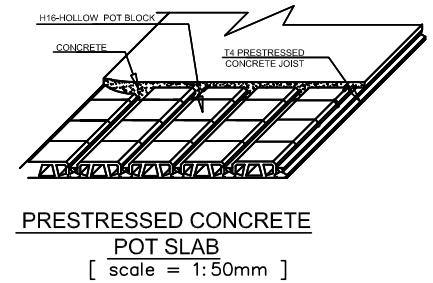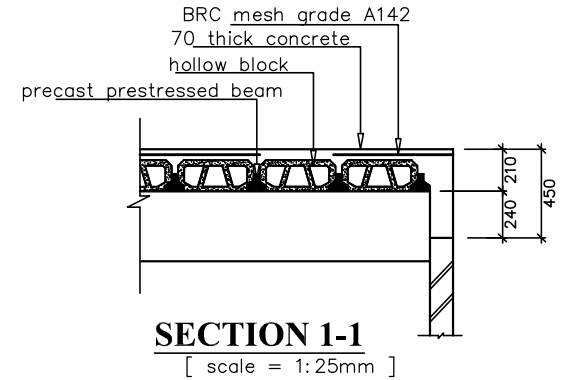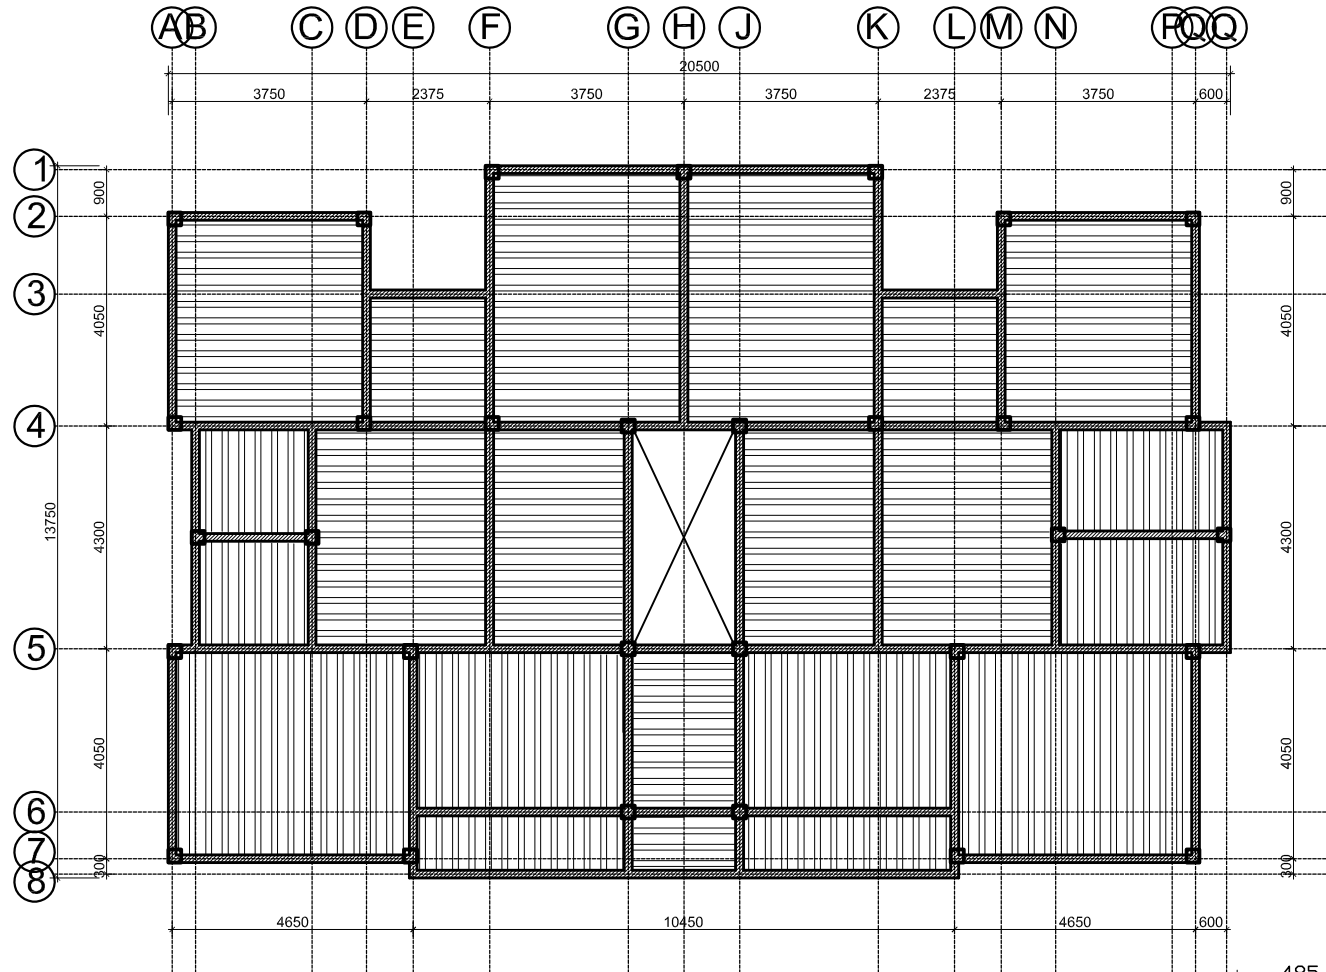

**H16- HOLLOW-POT BLOCK**  
[ scale = 1:50mm ]

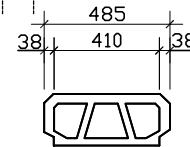

**FRONT VIEW OF H16-HOLLOW BLOCK**  
[ scale = 1:50mm ]

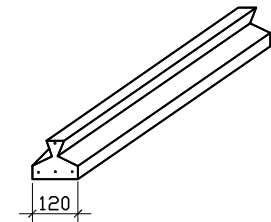

**T4 PRESTRESSED CONCRETE JOIST**  
[ scale = 1:50mm ]

**GENERAL ARRANGEMENT OF R.C FIRST, SECOND, THIRD & FOURTH FLOOR SLAB**

**NOTES**

Do not scale dimensions from drawings. Contractors, Sub-Contractors and Suppliers must verify all dimensions before commencing any work or making any shop drawings.


Should any divergence in dimensions occur between architectural, engineering or Sub-Contractors drawings, the Contractor shall immediately contact the Architect for clarification.

NO.	DESCRIPTION	DESIGN	CHECK	APPROVED	DATE

CLIENT:	ANSAH AGYEMANG BARIMAH AND RITA AGYEMANG BARIMAH
LOCATION:	ADWEMADOR -GREATER ACCRA REGION

PROJECT:	PROPOSED FIVE STOREY ADMINISTRATION BLOCK
DRAWING TITLE:	AS INDICATED

CHECKED BY:	NICHOLAS
DESIGNED BY:	NICHOLAS
DRAWN BY:	NICHOLAS
DATE:	NOV.2021
SCALE:	1:100 & 1:25
SHEET No.:	012
Drg. no.	<b>AR.21</b>
SHE. SIZE	-A3

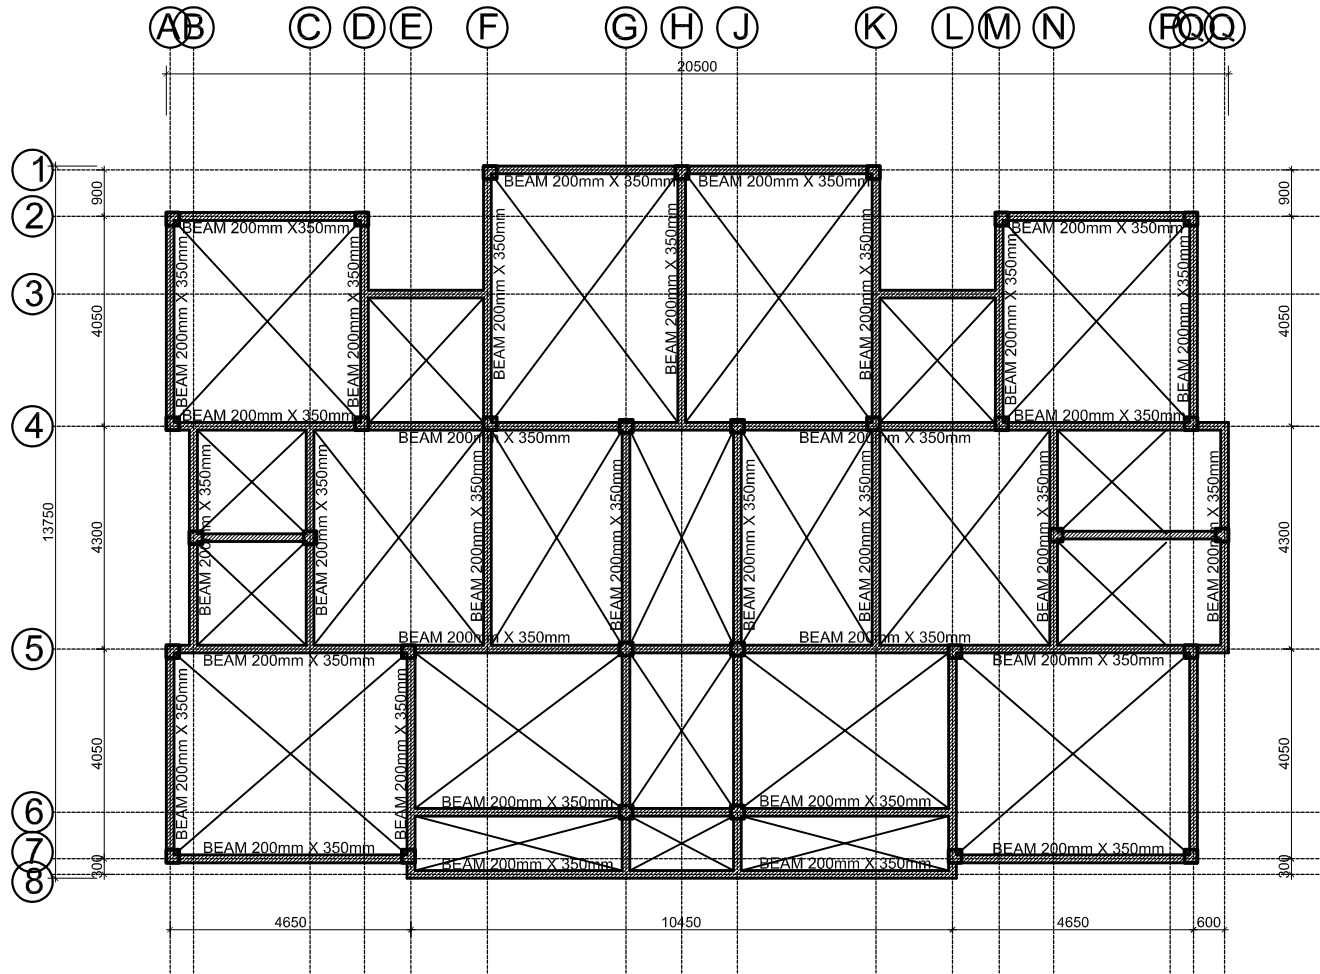

**R.C DETAILS OF  
ROOF BEAM LAYOUT**

**NOTES**

Do not scale dimensions from drawings. Contractors, Sub-Contractors and Suppliers must verify all dimensions before commencing any work or making any shop drawings.

Should any divergence in dimensions occur between architectural, engineering or Sub-Contractors drawings, the Contractor shall immediately contact the Architect for clarification.

NO.	DESCRIPTION	DESIGN	CHECK	APPROVED	DATE

CLIENT:	<b>ANSAH AGYEMANG BARIMAH AND RITA AGYEMANG BARIMAH</b>
LOCATION:	<b>ADWEMADOR -GREATER ACCRA REGION</b>


PROJECT:	<b>PROPOSED FIVE STOREY ADMINISTRATION BLOCK</b>
DRAWING TITLE:	<b>AS INDICATED</b>

CHECKED BY:	
DESIGNED BY:	NICHOLAS
DRAWN BY:	NICHOLAS
DATE:	NOV.2021
SCALE:	1:100 & 1:25
SHEET No.:	012

**Drg. no.**  
**AR.22**

SHE. SIZE -A3



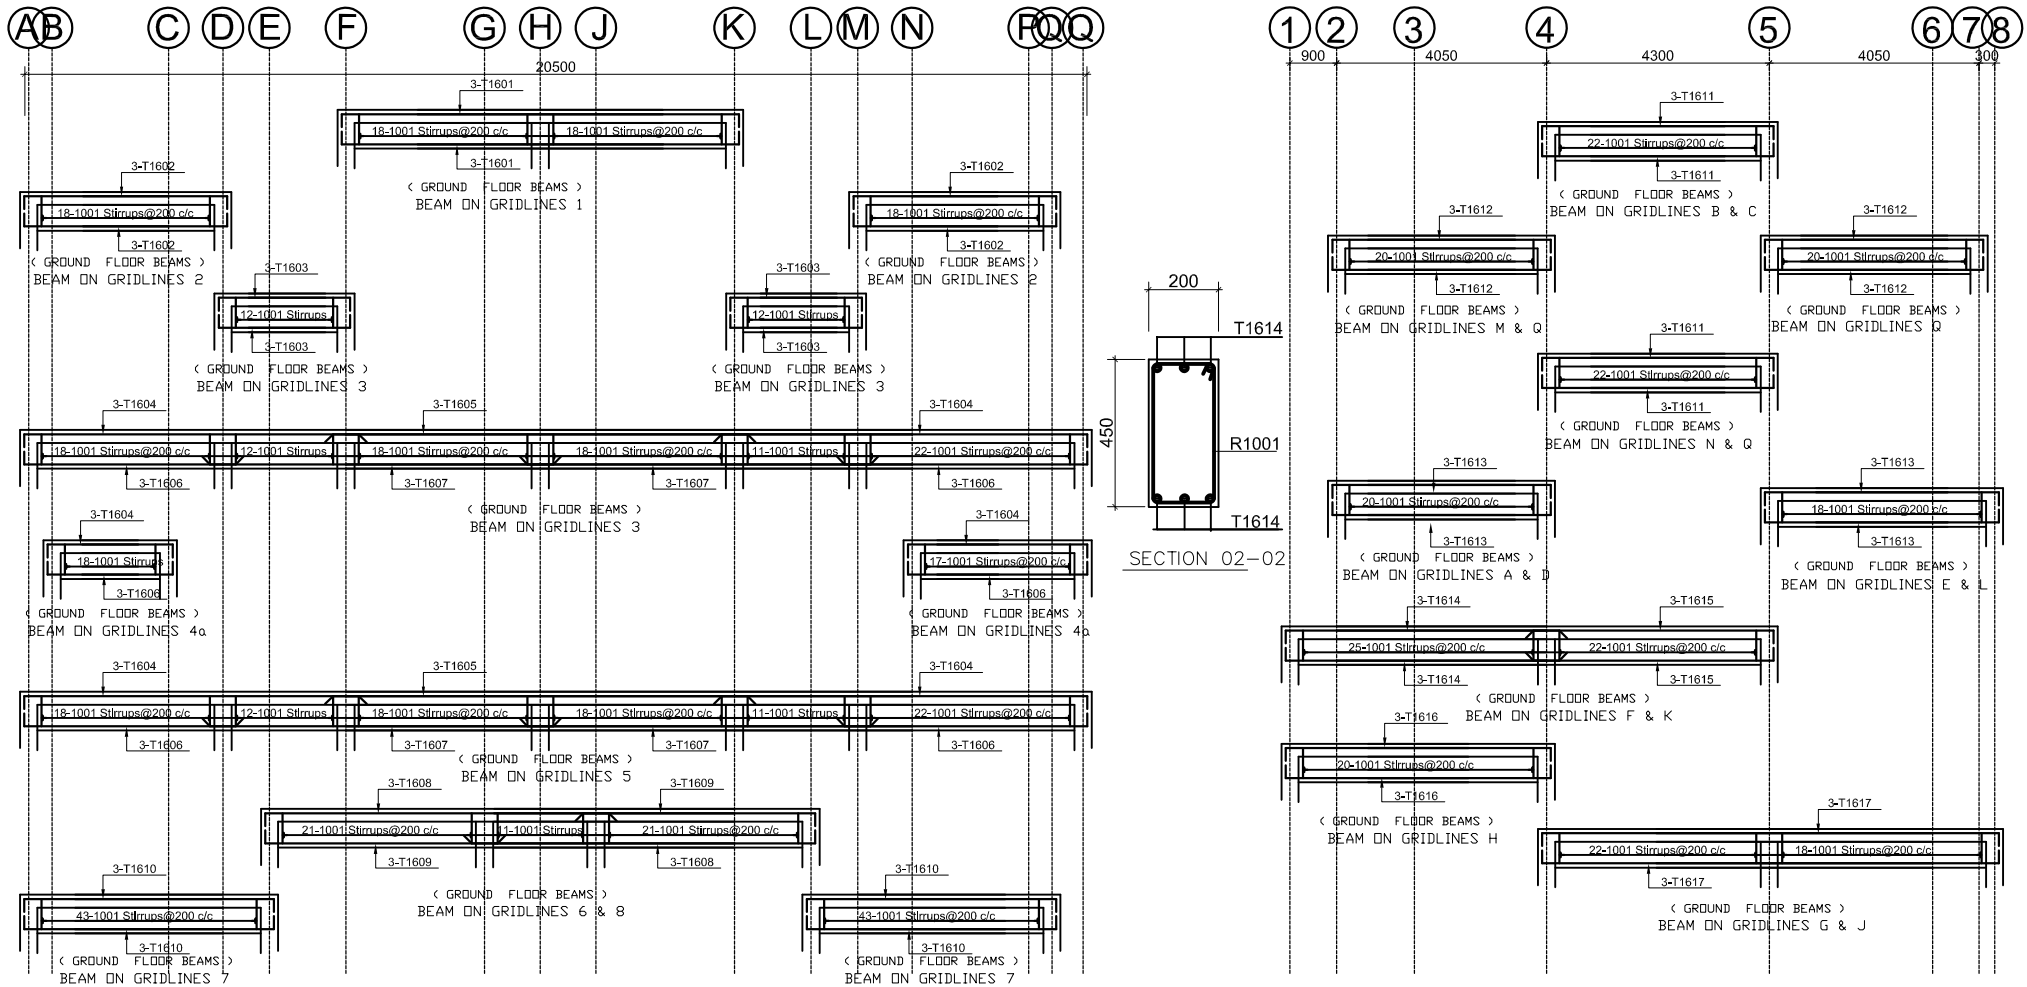

**NOTES**

Do not scale dimensions from drawings. Contractors, Sub-Contractors and Suppliers must verify all dimensions before commencing any work or making any shop drawings.

Should any divergence in dimensions occur between architectural, engineering or Sub-Contractors drawings, the Contractor shall immediately contact the Architect for clarification.


NO.	DESCRIPTION	DESIGN	CHECK	APPROVED	DATE

CLIENT:	ANSAH AGYEMANG BARIMAH AND RITA AGYEMANG BARIMAH
LOCATION:	ADWEMADOR - GREATER ACCRA REGION


PROJECT:	PROPOSED FIVE STOREY ADMINISTRATION BLOCK
DRAWING TITLE:	AS INDICATED

CHECKED BY:	NICHOLAS
DESIGNED BY:	NICHOLAS
DRAWN BY:	NICHOLAS
DATE:	NOV.2021
SCALE:	1:100 & 1:25
SHEET No.:	012


Drg. no.  
**AR.24**  
SHE. SIZE -A3

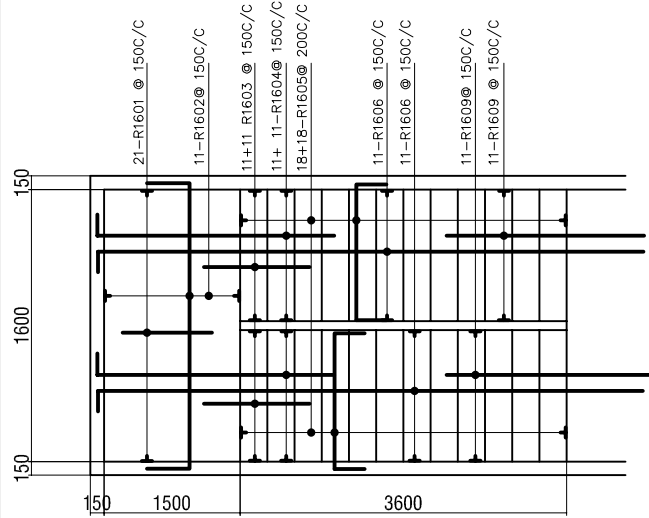


R.C STAIR CASE FROM FIRST FL. TO SECOND FLOOR

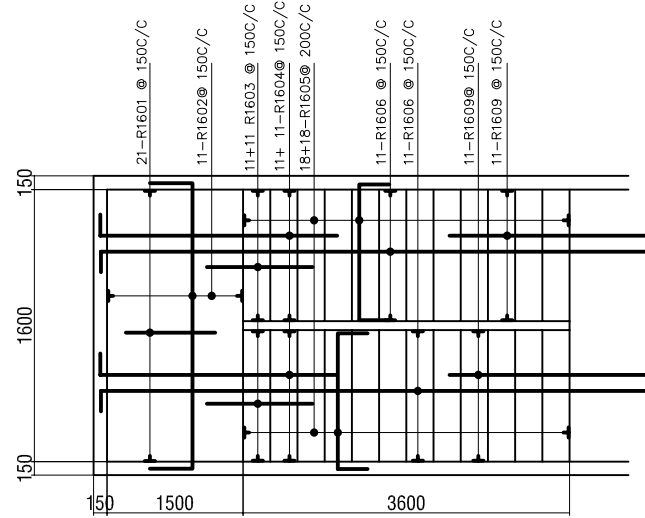


R.C STAIR CASE FROM THIRD FL. TO FOURTH FLOOR

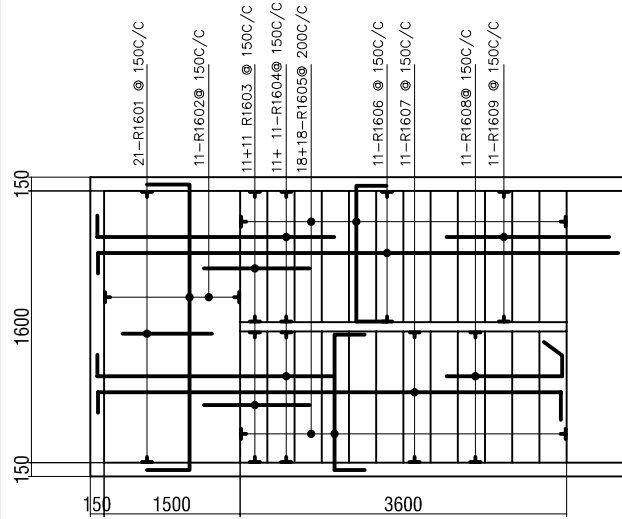

R.C STAIR CASE FROM GROUND FL. TO FIRST FLOOR

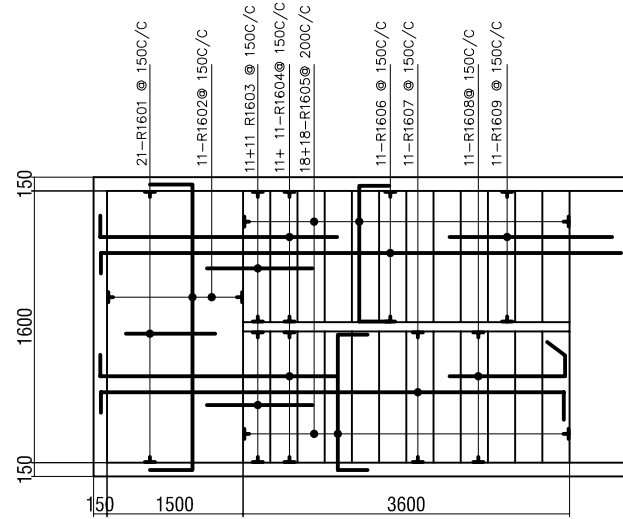

R.C STAIR CASE FROM SECOND FL. TO THIRD FLOOR

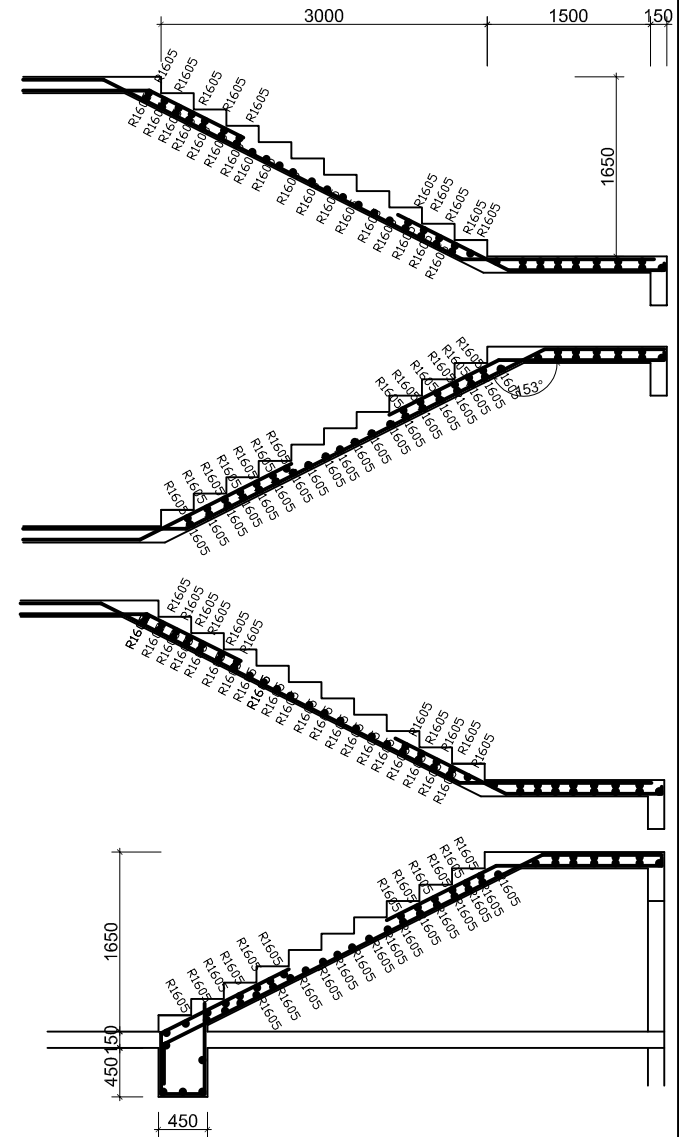

NO.	DESCRIPTION	DESIGN	CHECK	APPROVED	DATE

**NOTES**

Do not scale dimensions from drawings. Contractors, Sub-Contractors and Suppliers must verify all dimensions before commencing any work or making any shop drawings.

Should any divergence in dimensions occur between architectural, engineering or Sub-Contractors drawings, the Contractor shall immediately contact the Architect for clarification.

CLIENT: **ANSAH AGYEMANG BARIMAH AND RITA AGYEMANG BARIMAH**

LOCATION: **ADWEMADOR - GREATER ACCRA REGION**

PROJECT: **PROPOSED FIVE STOREY ADMINISTRATION BLOCK**

DRAWING TITLE: **AS INDICATED**

CHECKED BY: **NICHOLAS**

DESIGNED BY: **NICHOLAS**

DRAWN BY: **NICHOLAS**

DATE: **NOV.2021**

SCALE: **1:100 & 1:25**

SHEET No.: **012**

Dr. no. **AR.27**

SHE. SIZE -A3

**PROPOSED FIVE STOREY ADMINISTRATION BLOCK**

FOR:

**ANSAH AGYEMANG BARIMAH AND  
RITA AGYEMANG BARIMAH**

**AT**

**ADWEMADOR -GREATER ACCRA REGION**